




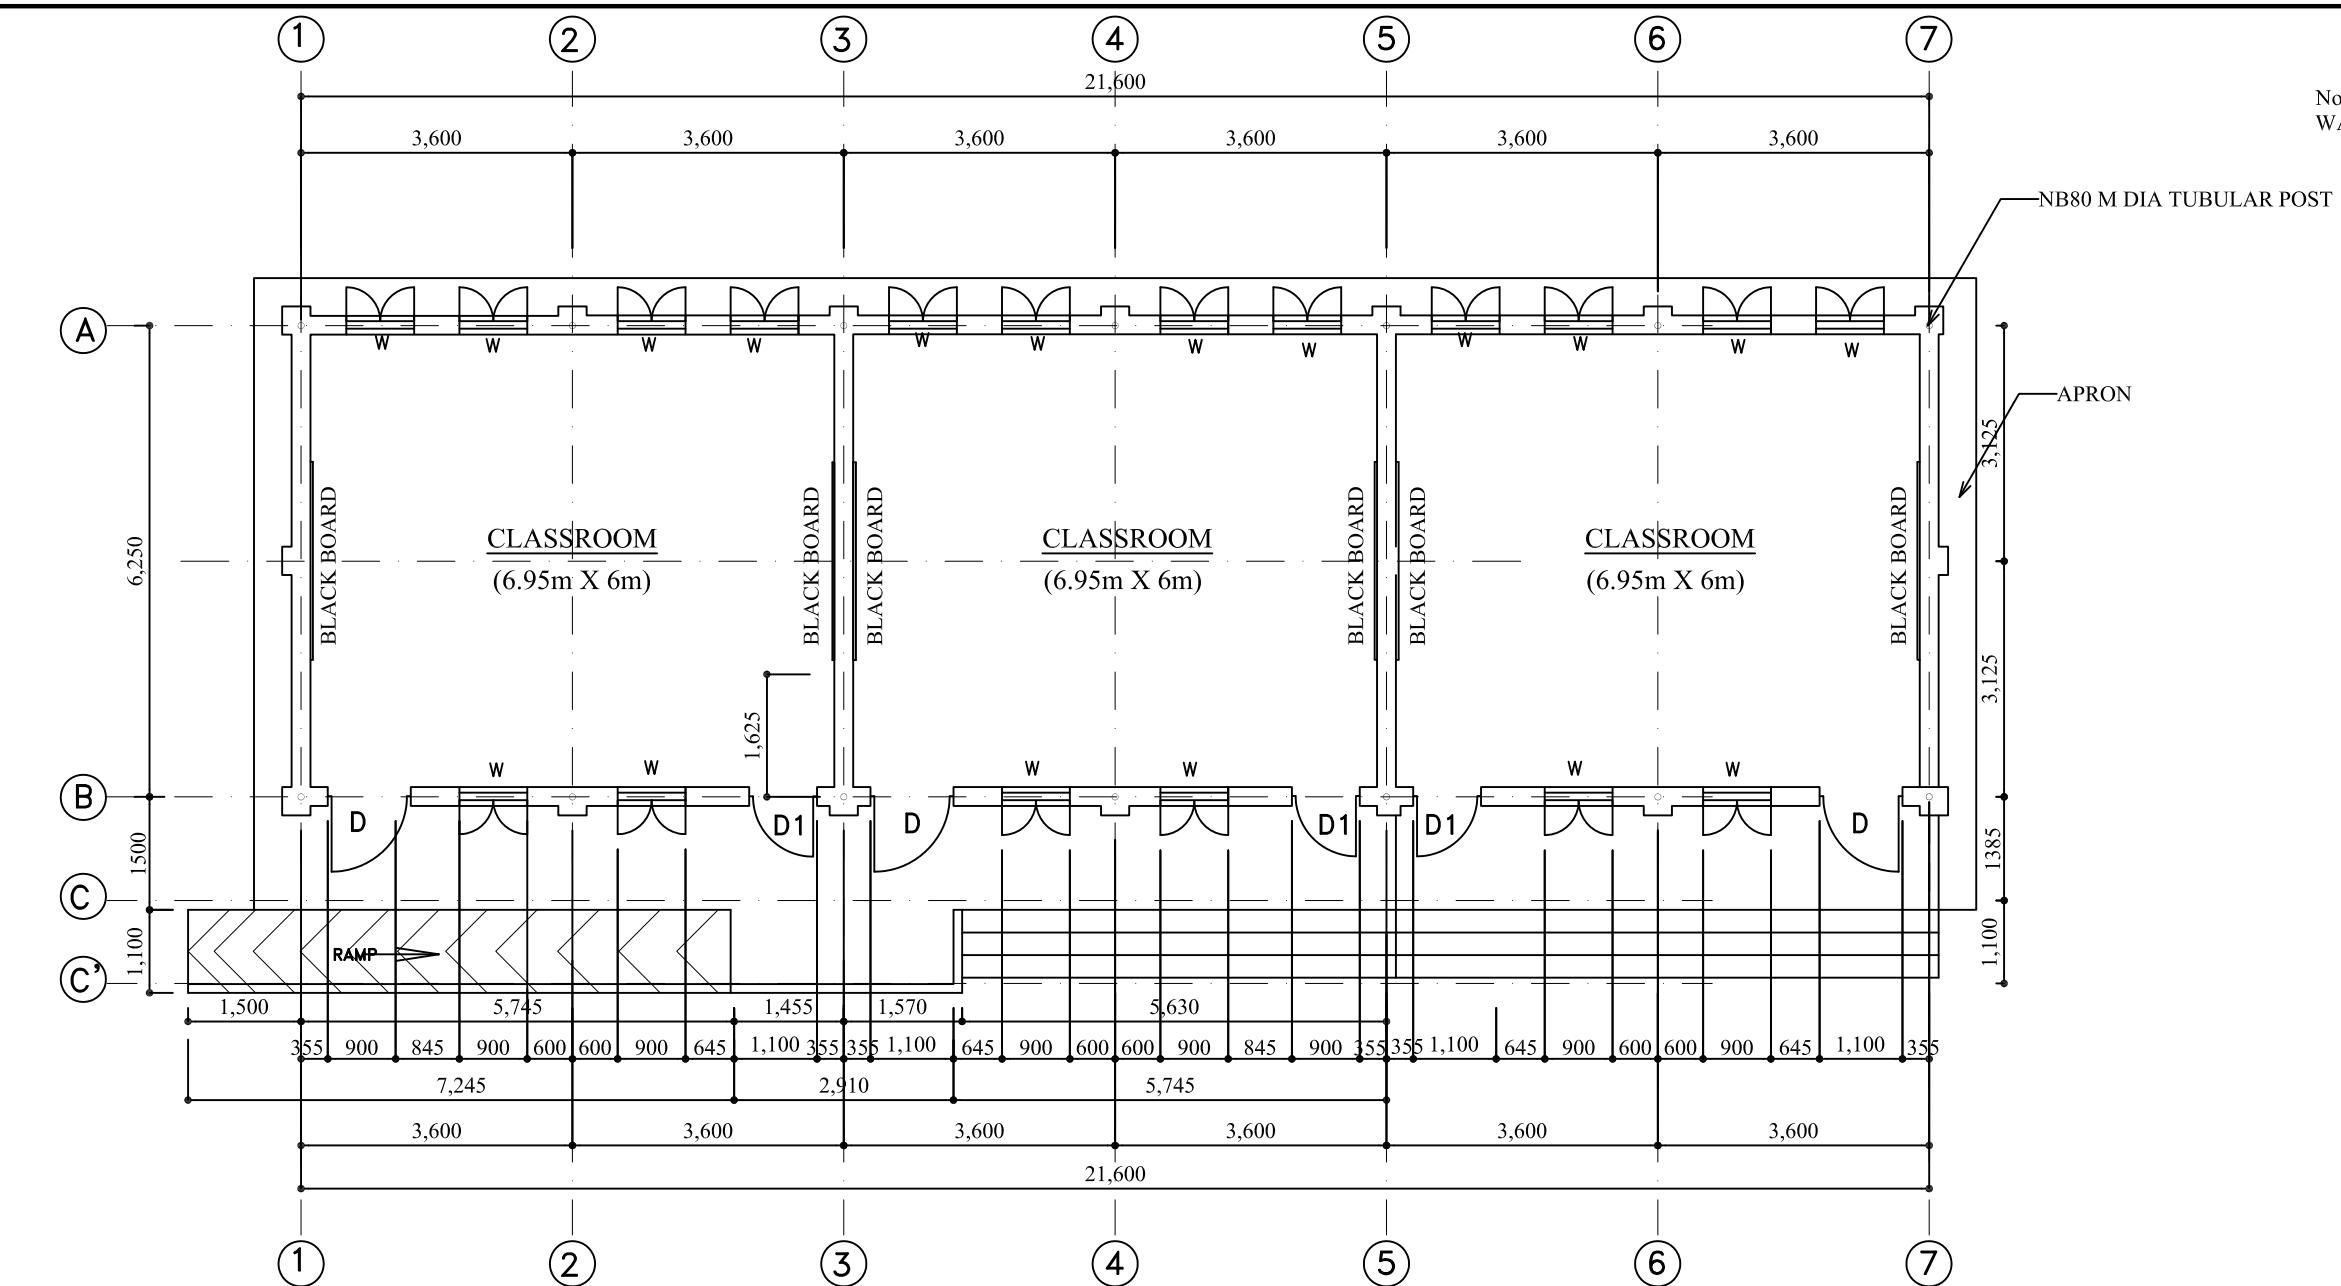


PLAN

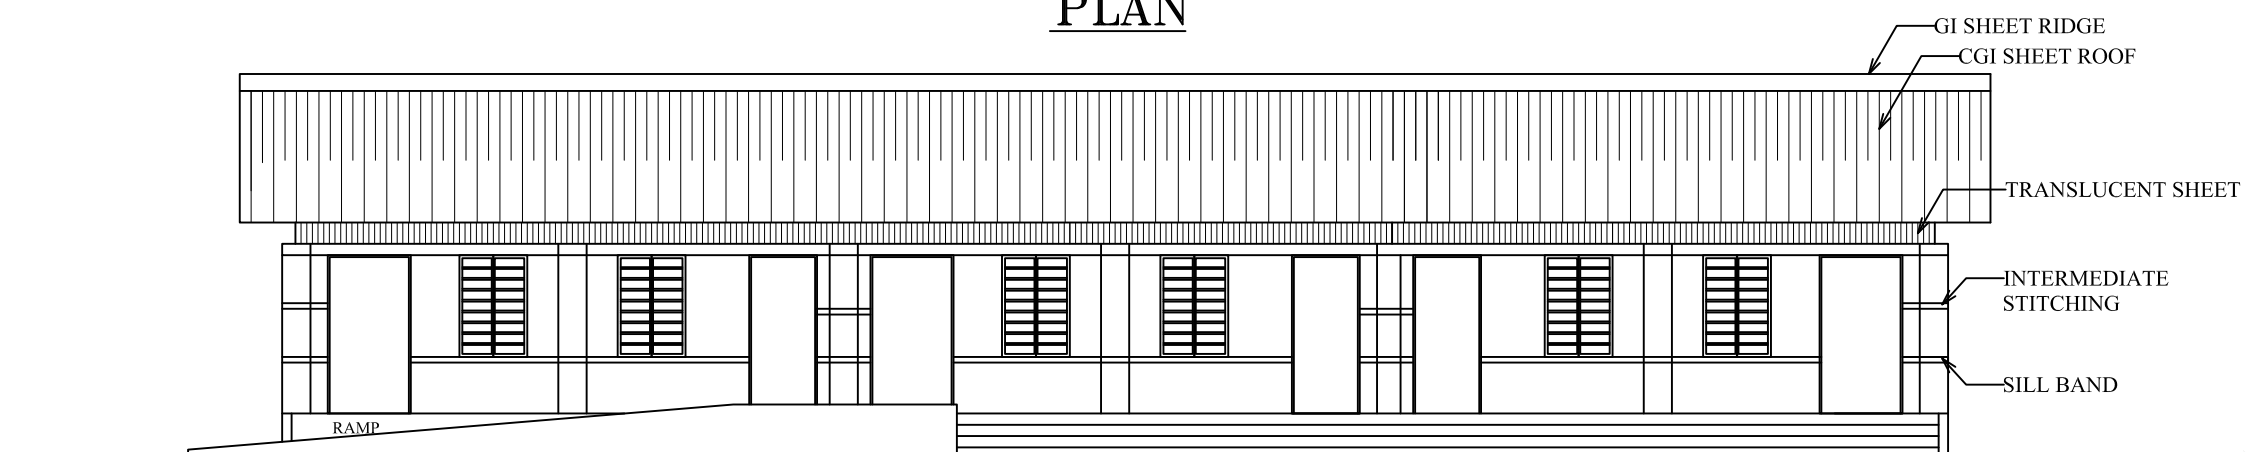


FRONT ELEVATION

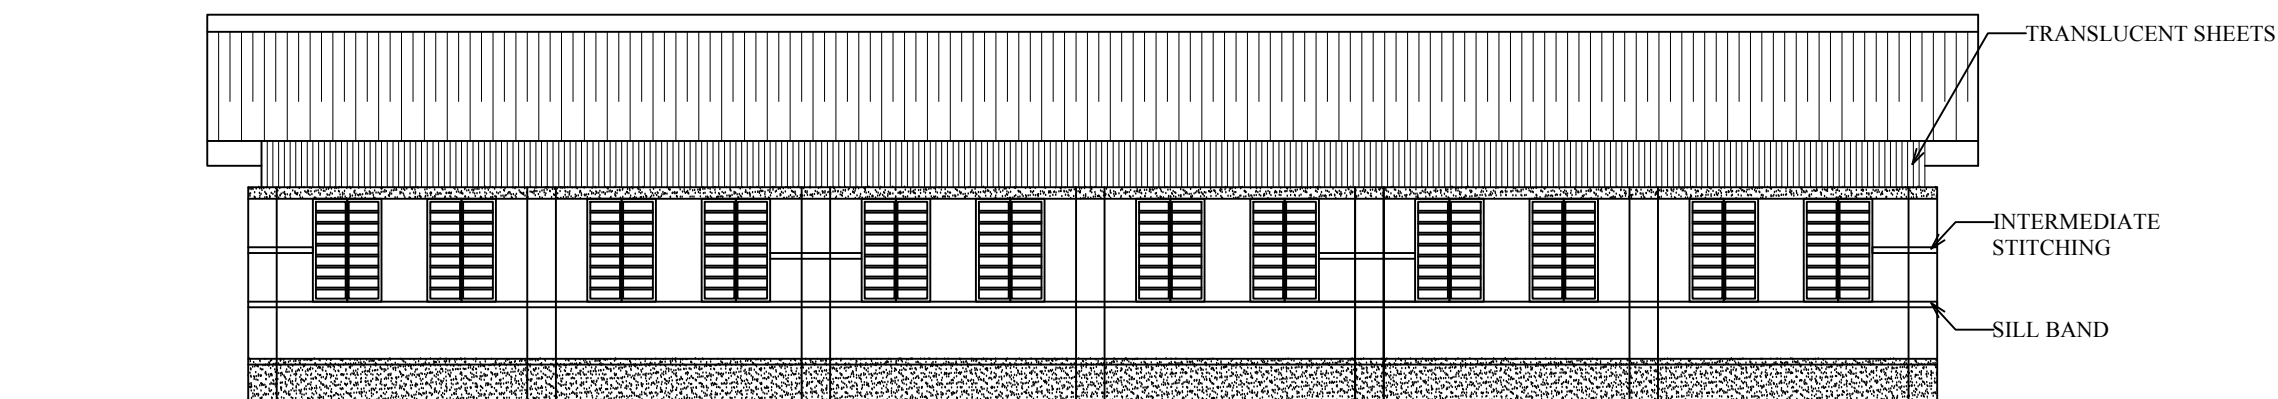

BACK ELEVATION

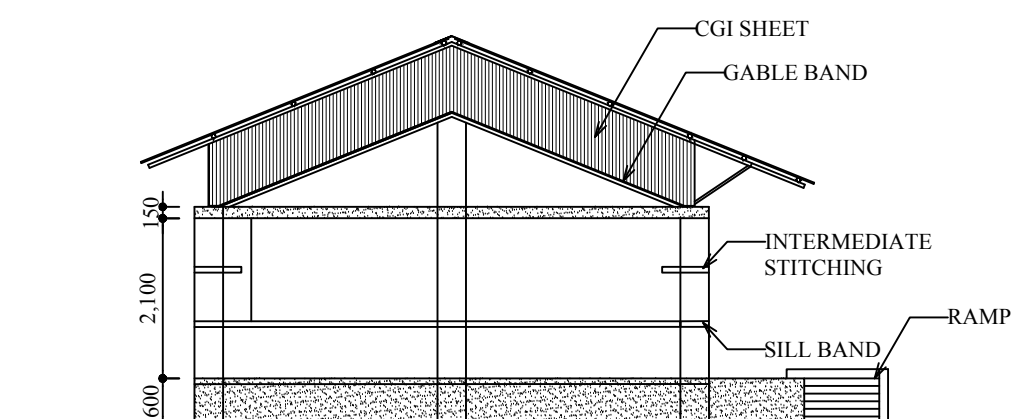


SIDE ELEVATION

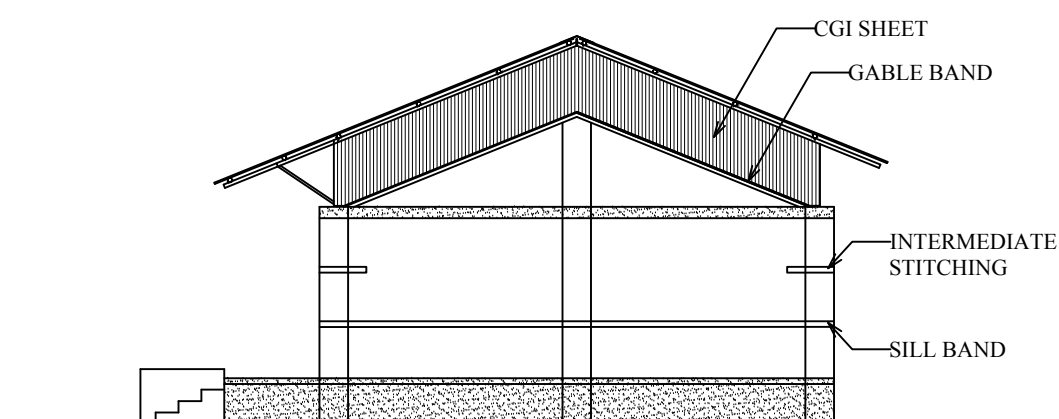


SIDE ELEVATION



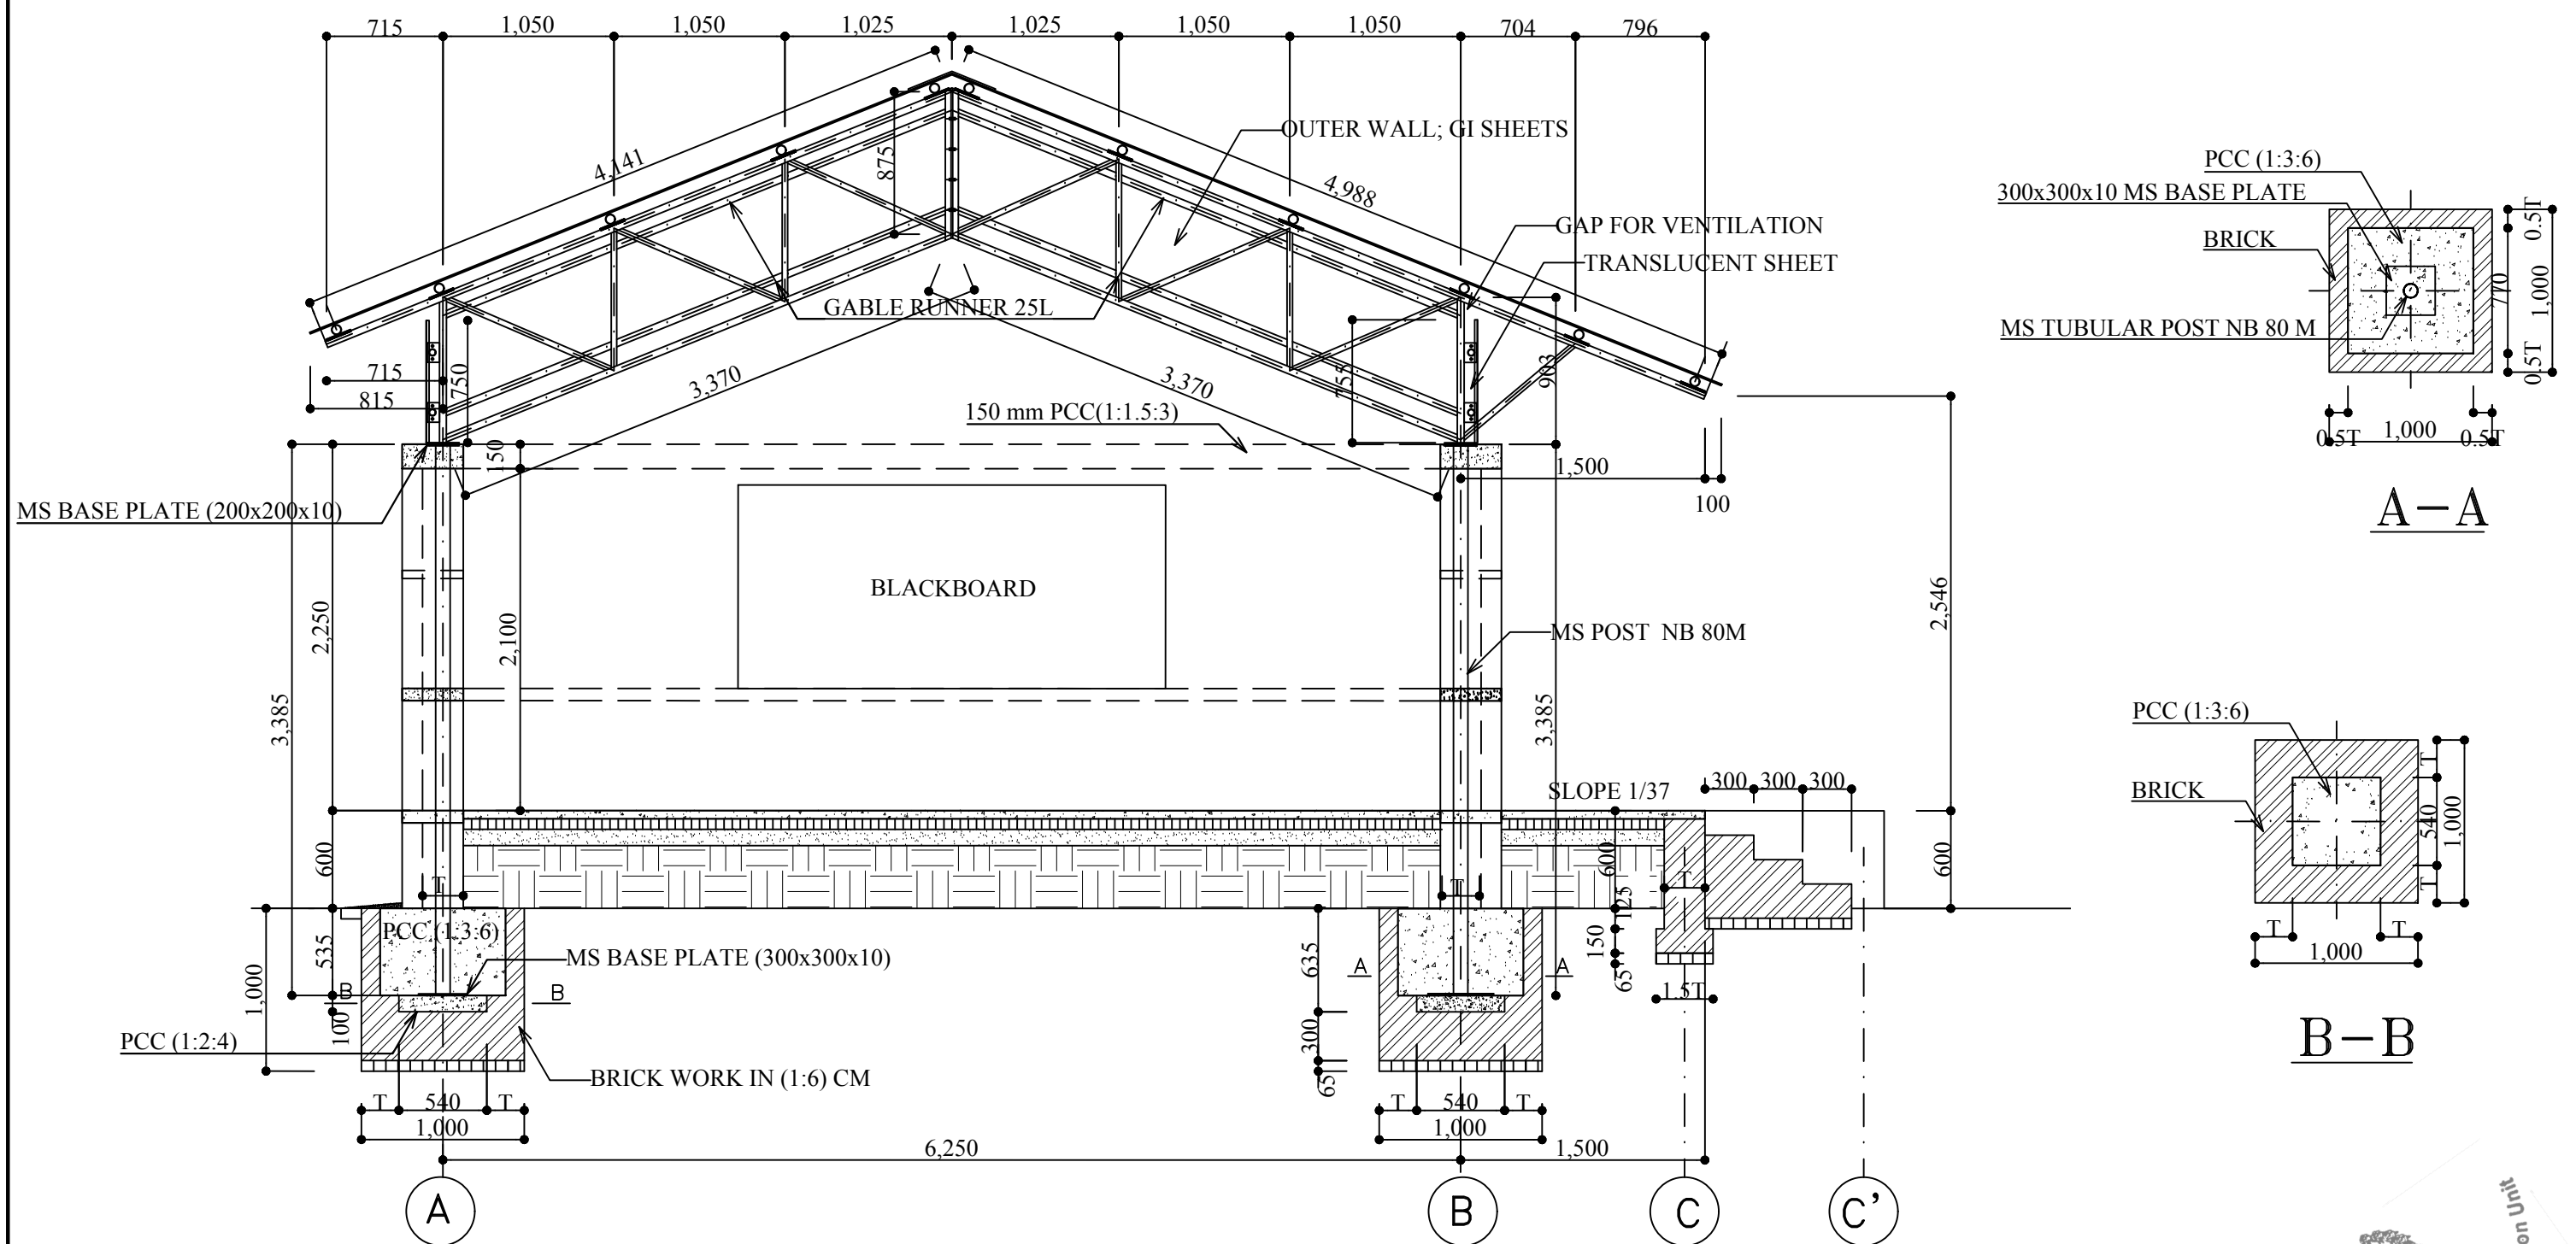


SECTION AT GRID 1-1, 3-3, 5-5, 7-7

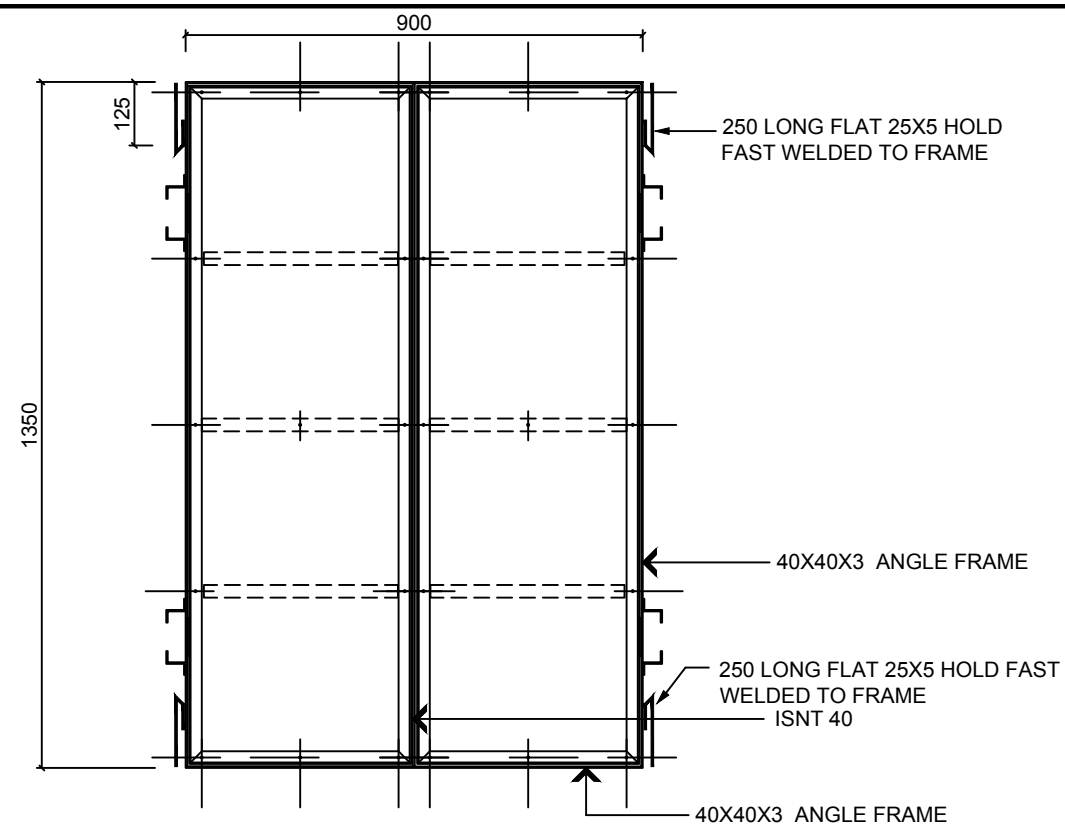


(FRAME ELEVATION LOOKING FROM OUTSIDE)


WINDOW (W)

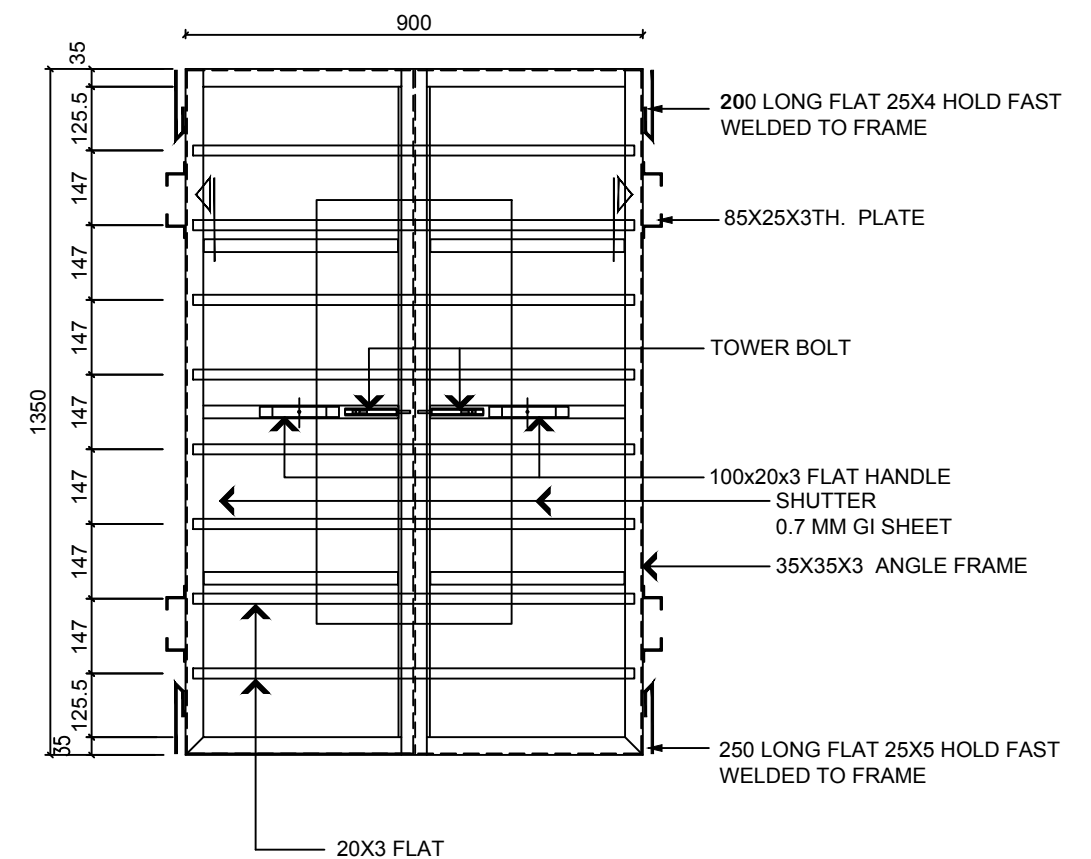


(FRAME ELEVATION LOOKING FROM INSIDE)

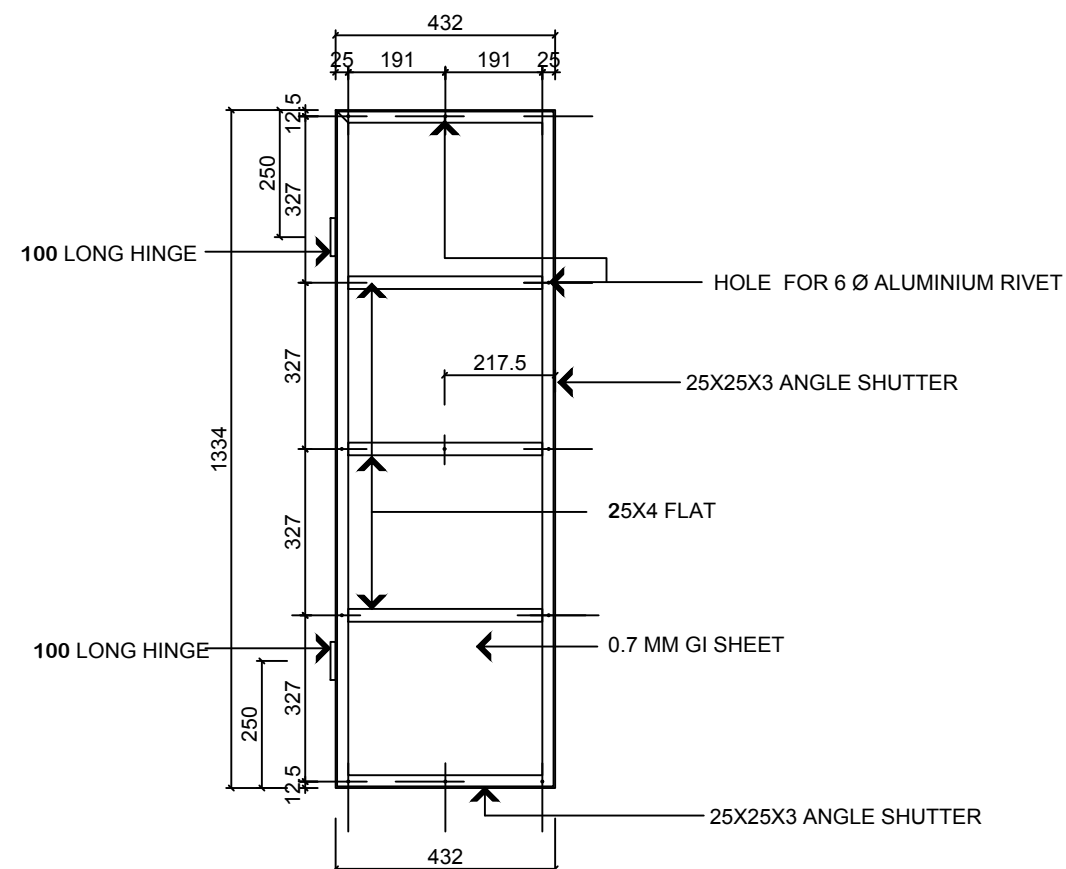


BACK VIEW OF WINDOW SHUTTER

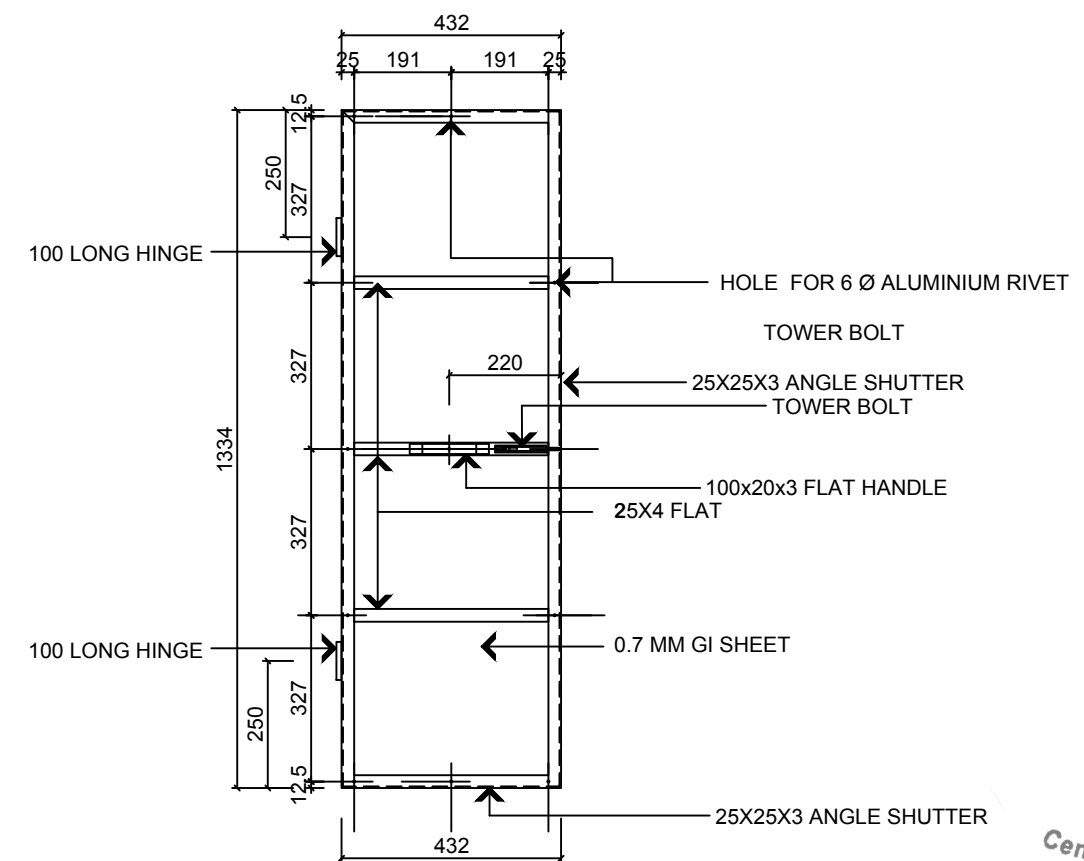

INSIDE VIEW OF WINDOW SHUTTER

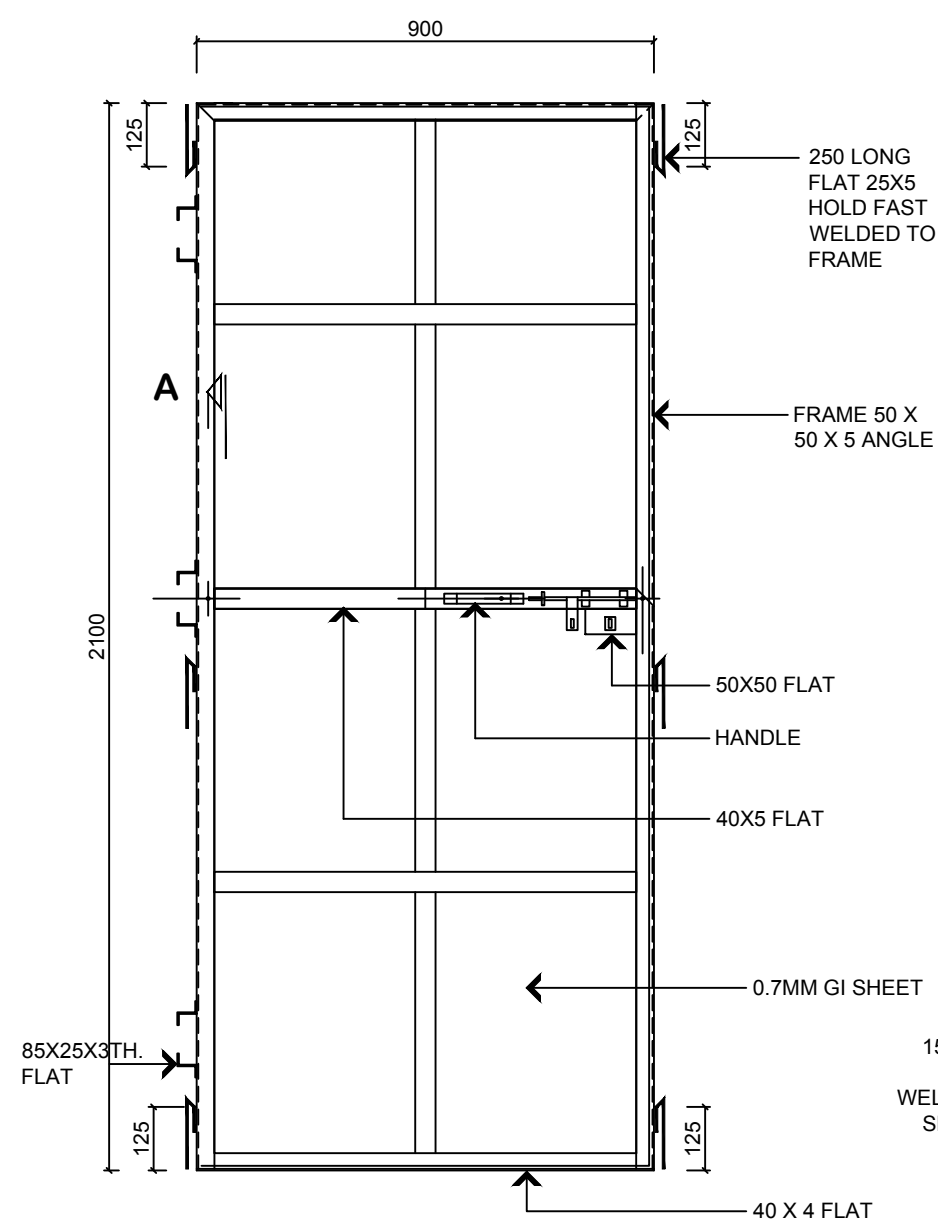


(FRAME ELEVATION LOOKING FROM
OUTSIDE)

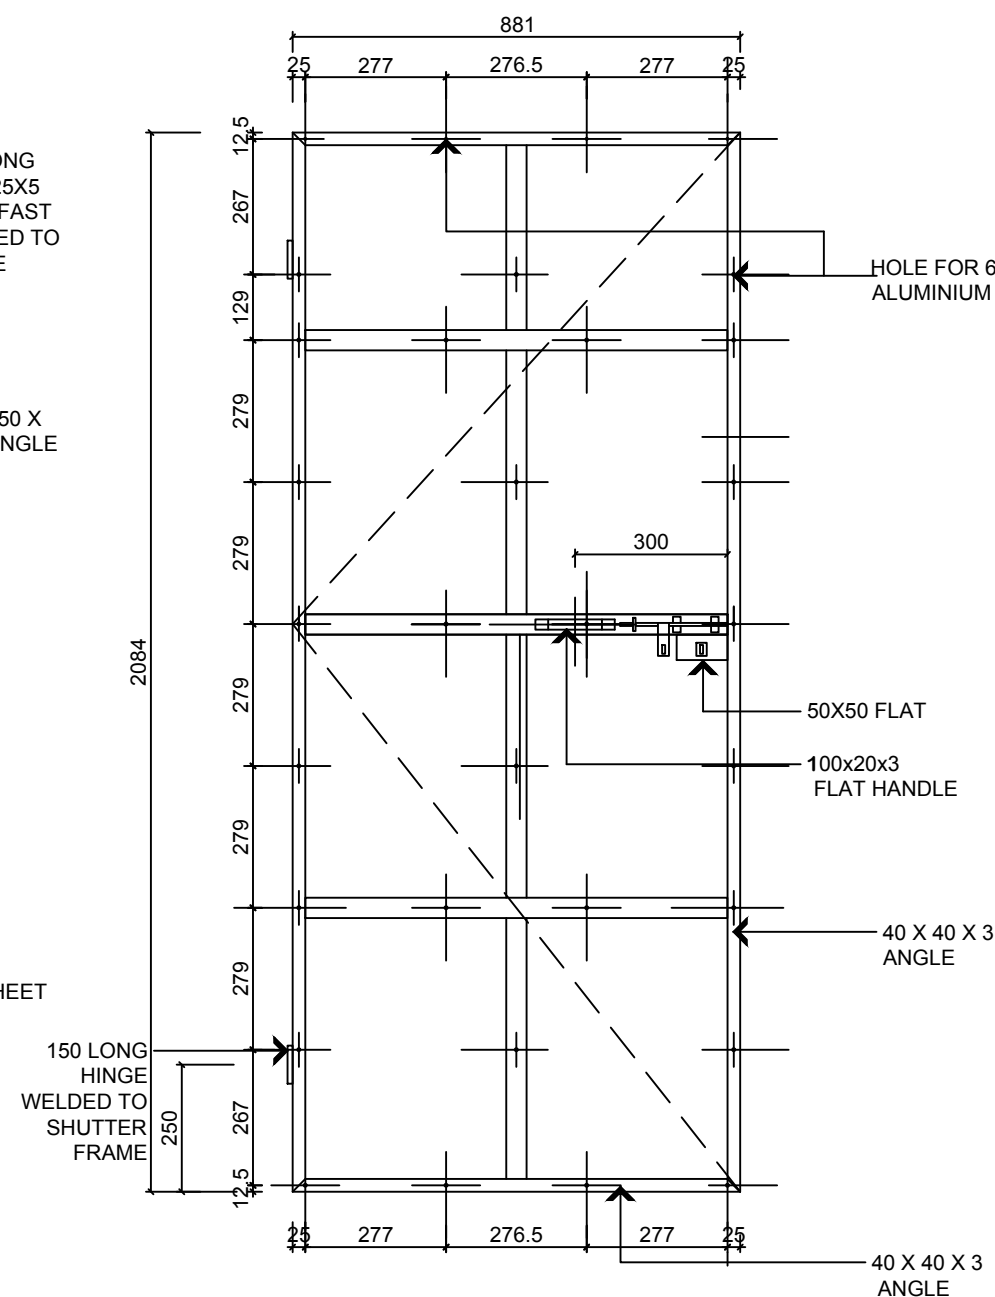

(LOOKING FROM OUTSIDE)
SHUTTER ELEVATION

DOOR (D1)

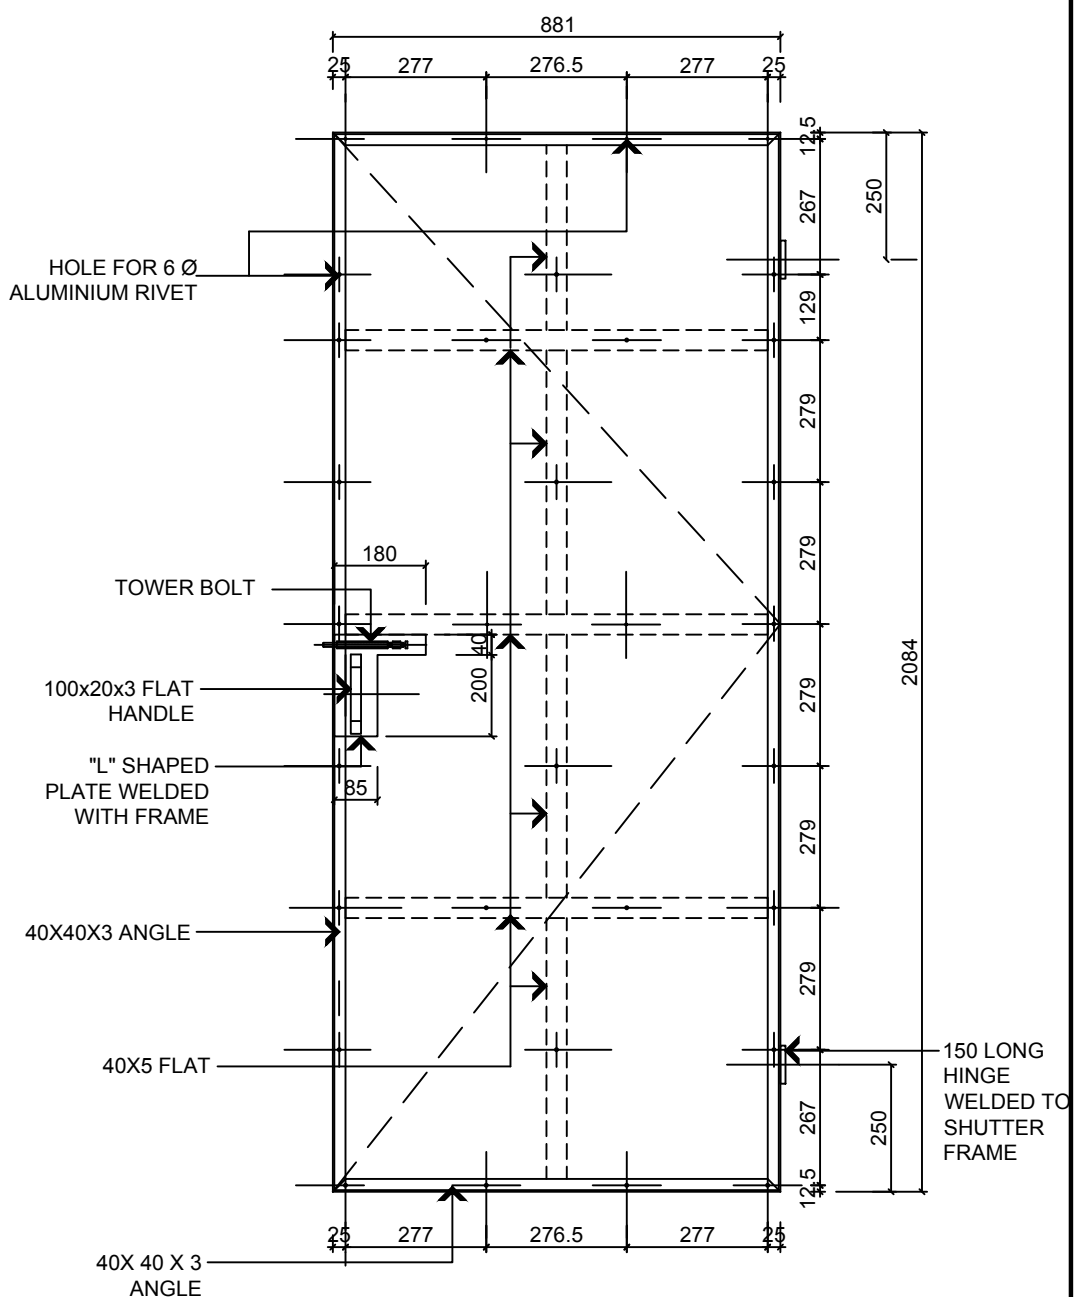


(LOOKING FROM INTSIDE)
SHUTTER ELEVATION











ION

Government of Nepal
Ministry of Education
Central Level Project Implementation Unit
Gyaneshwor, Kathmandu


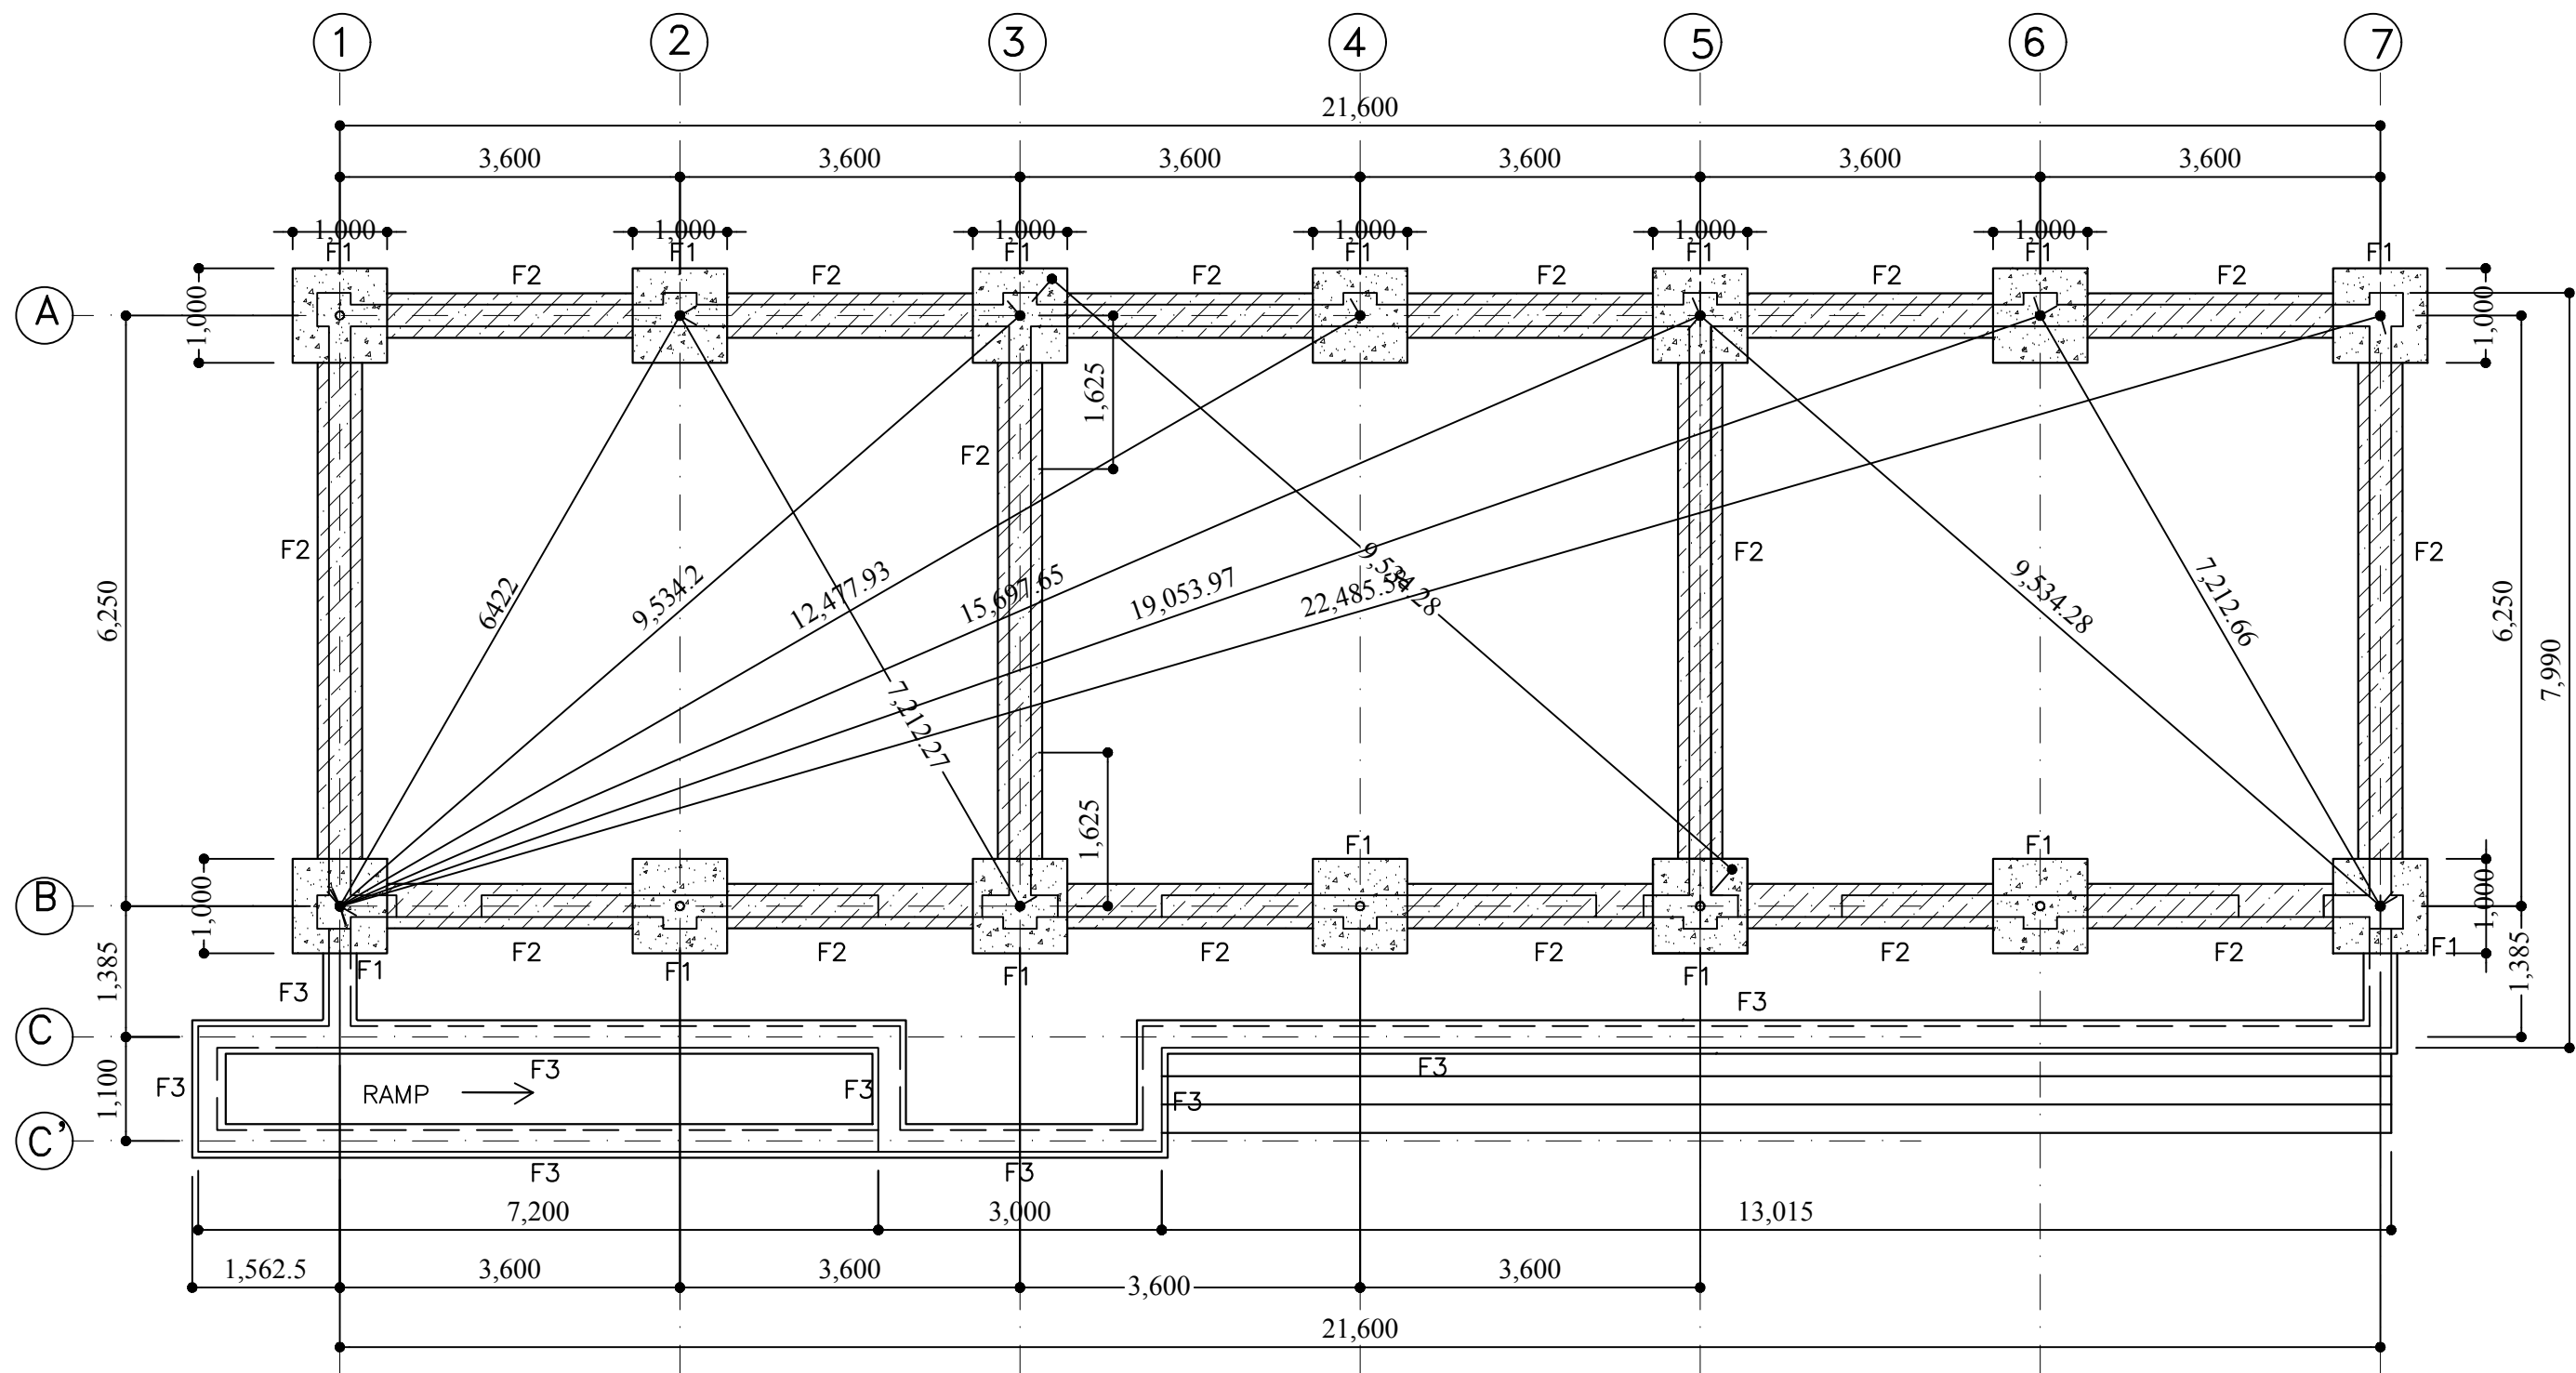


TRENCH PLAN

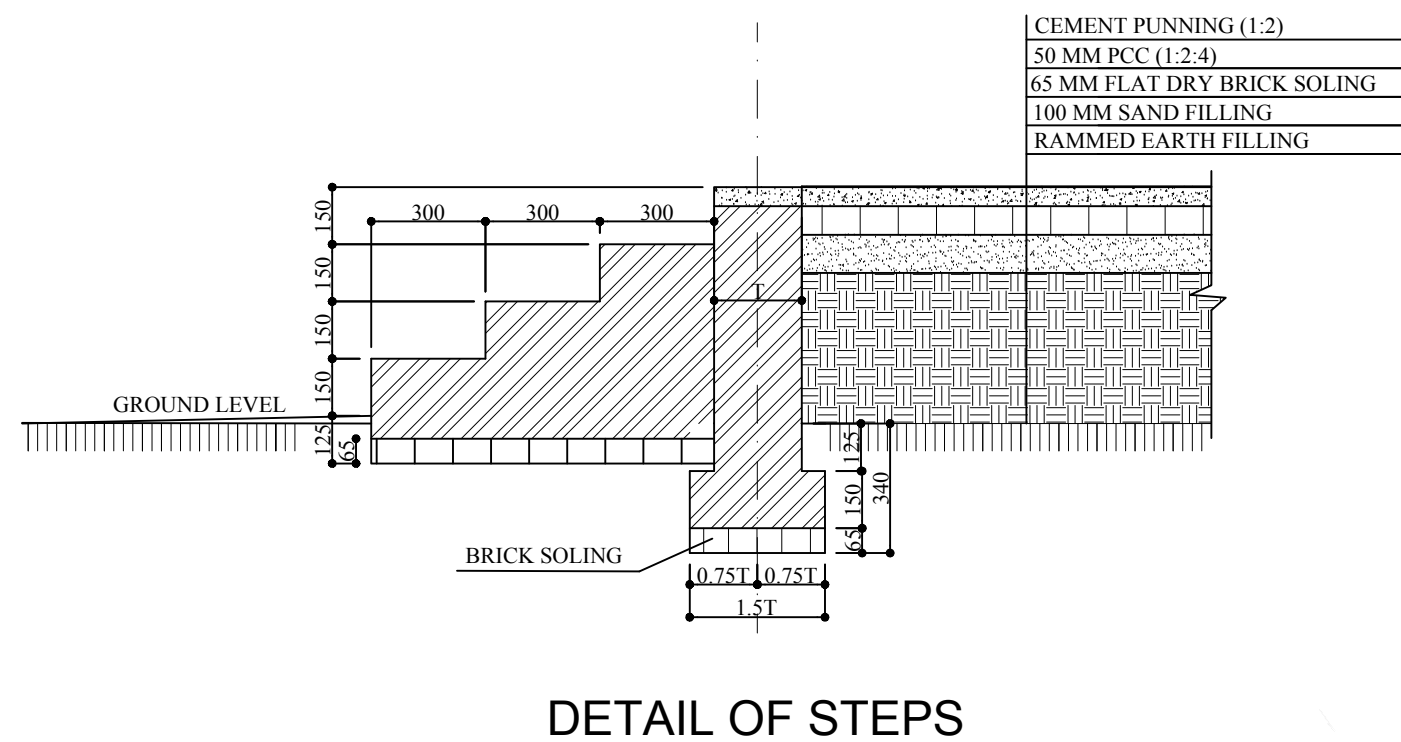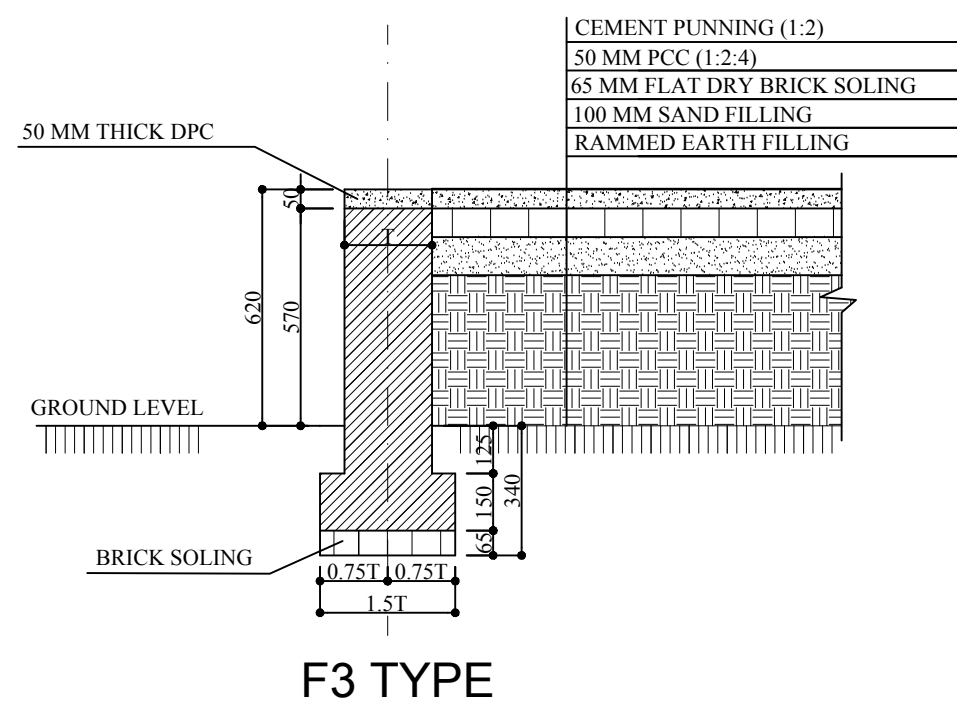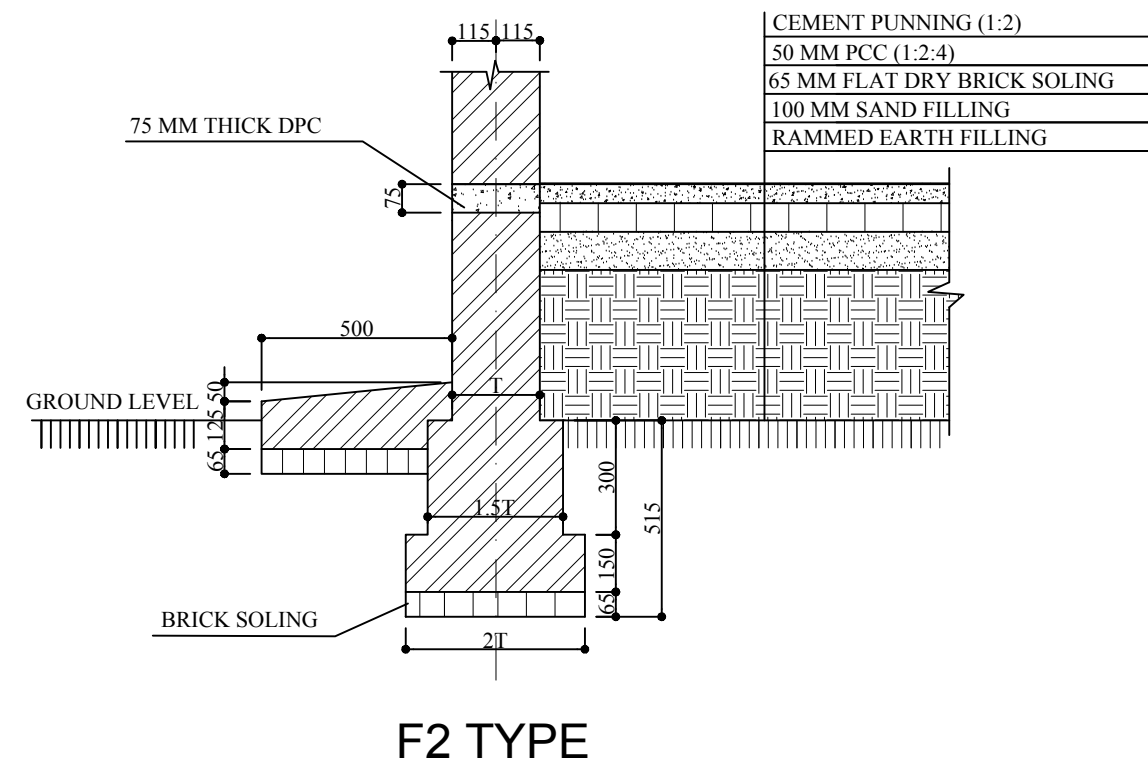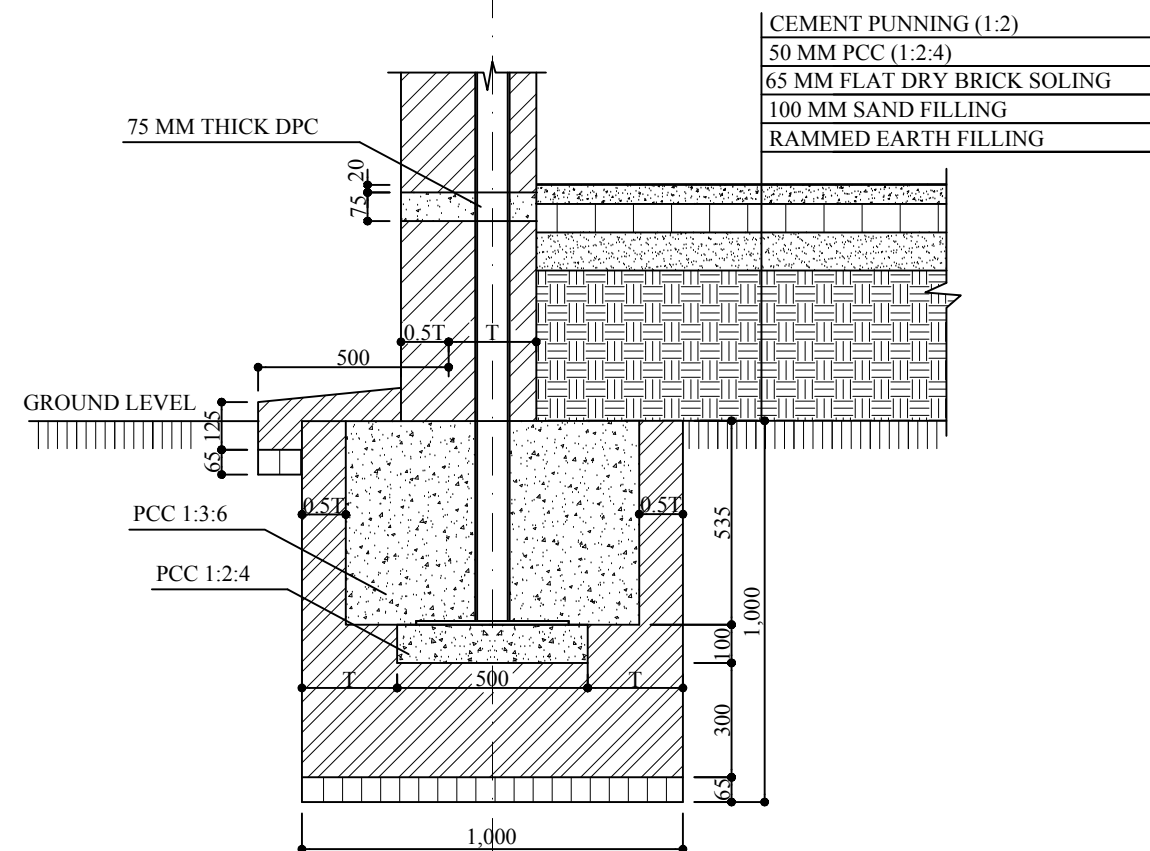

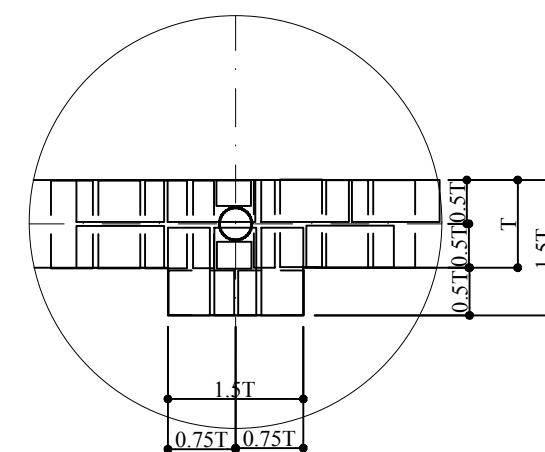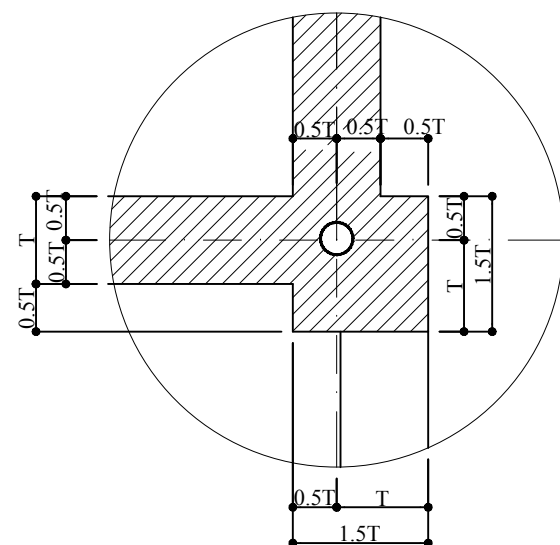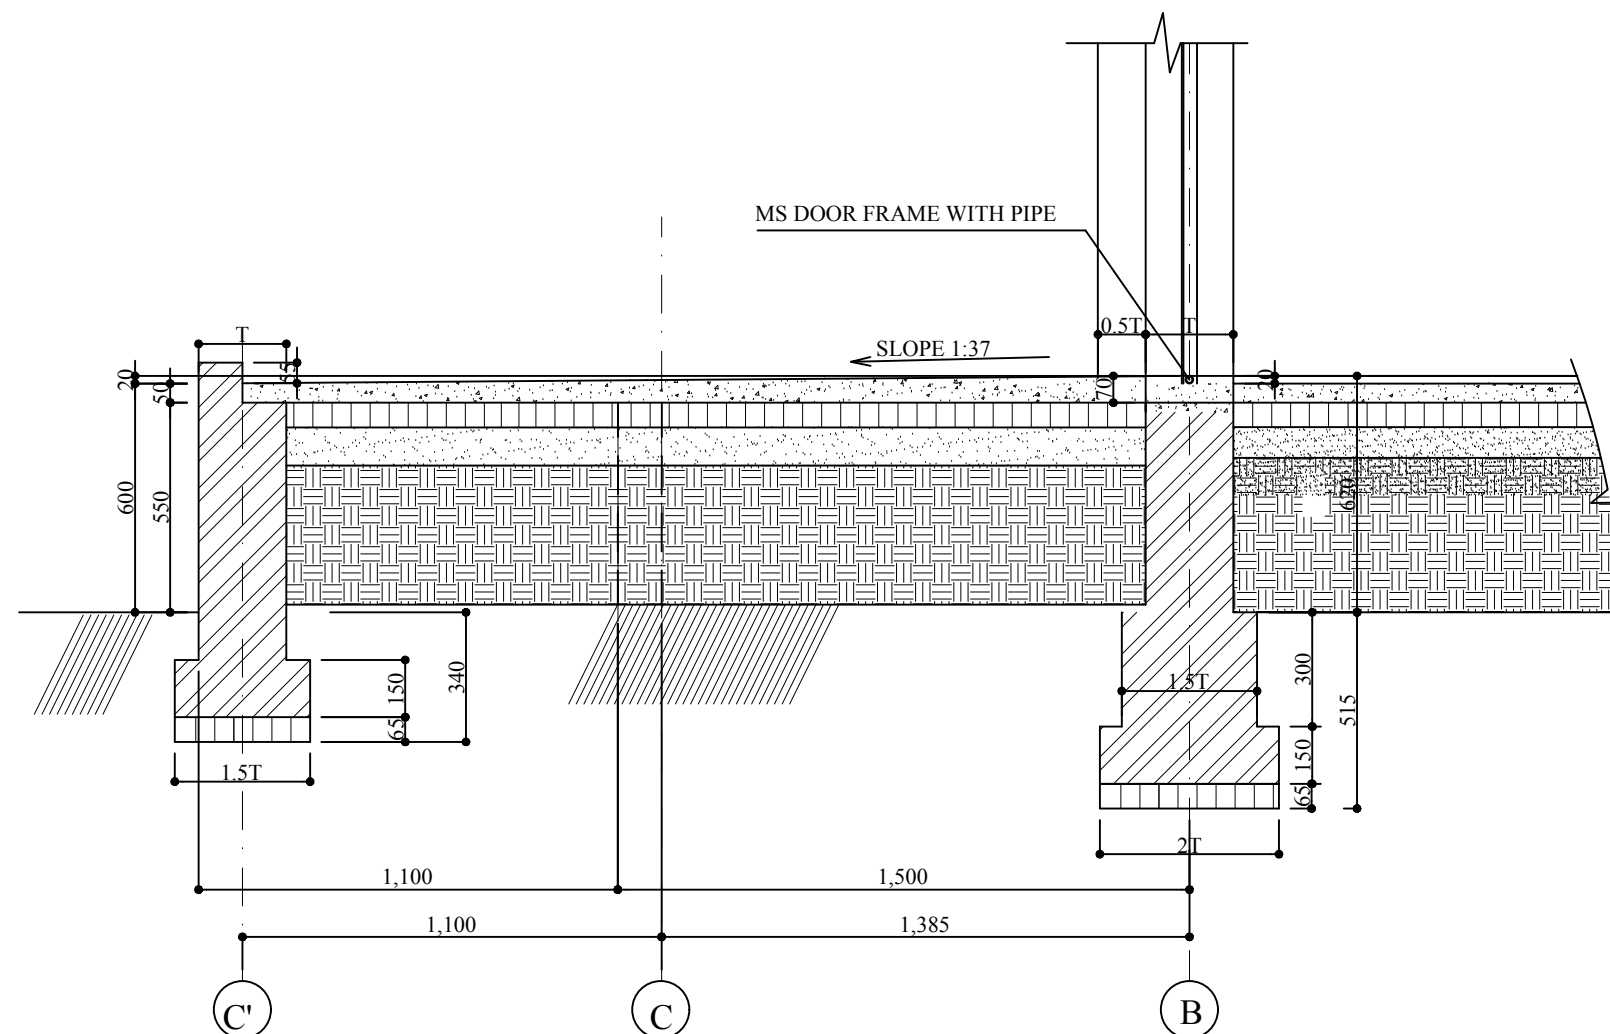
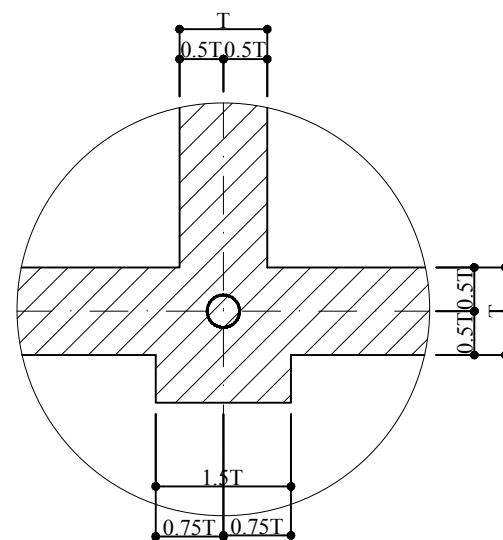


PLAN FOR DPC AND GABLE BAND

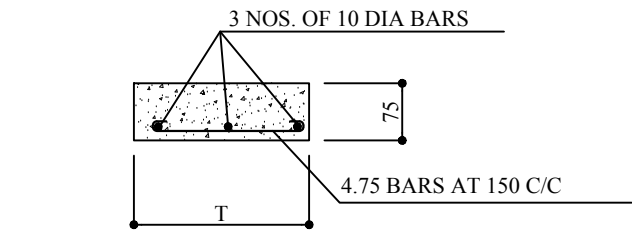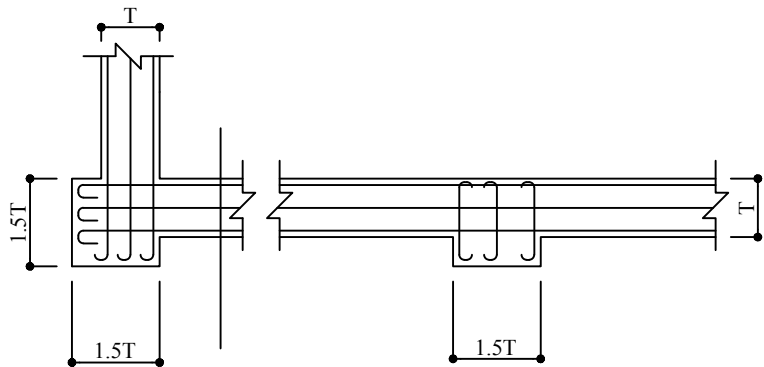




DPC AND GABLE BAND SECTION

PLAN FOR SILL AND LINTEL BAND

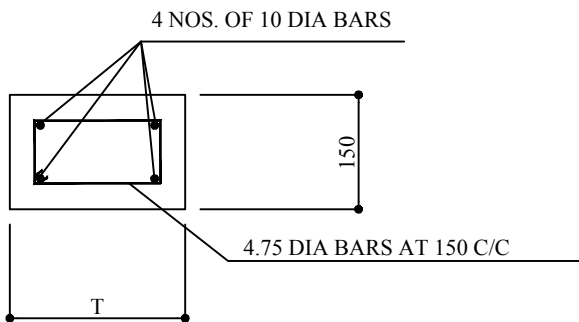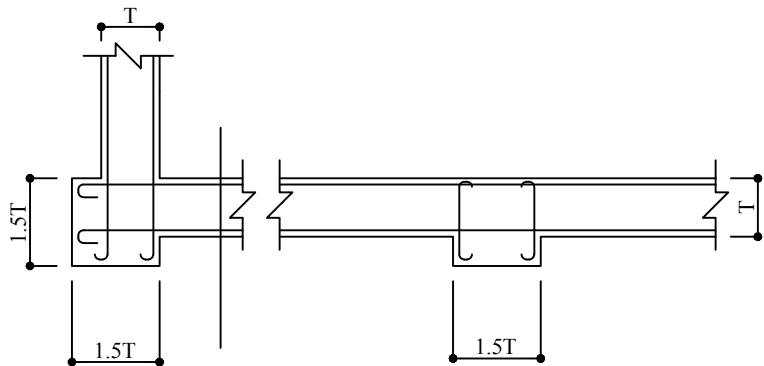


LINTEL BAND SECTION

STICHING BAND

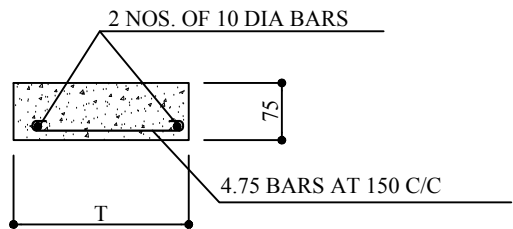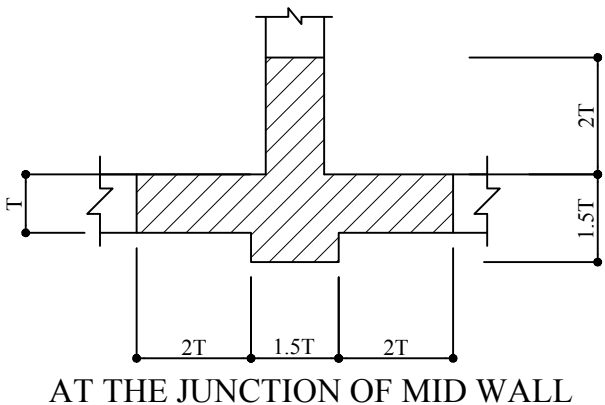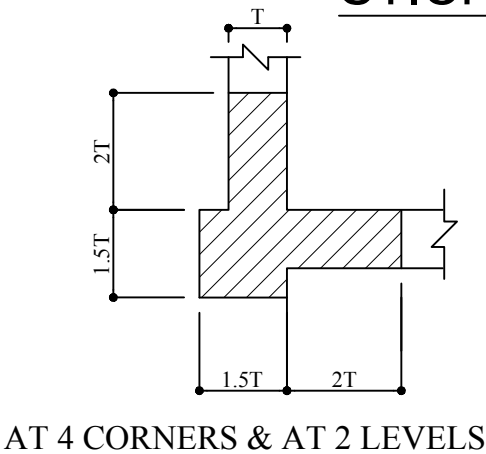


STITCHING AND SILL BAND SECTION





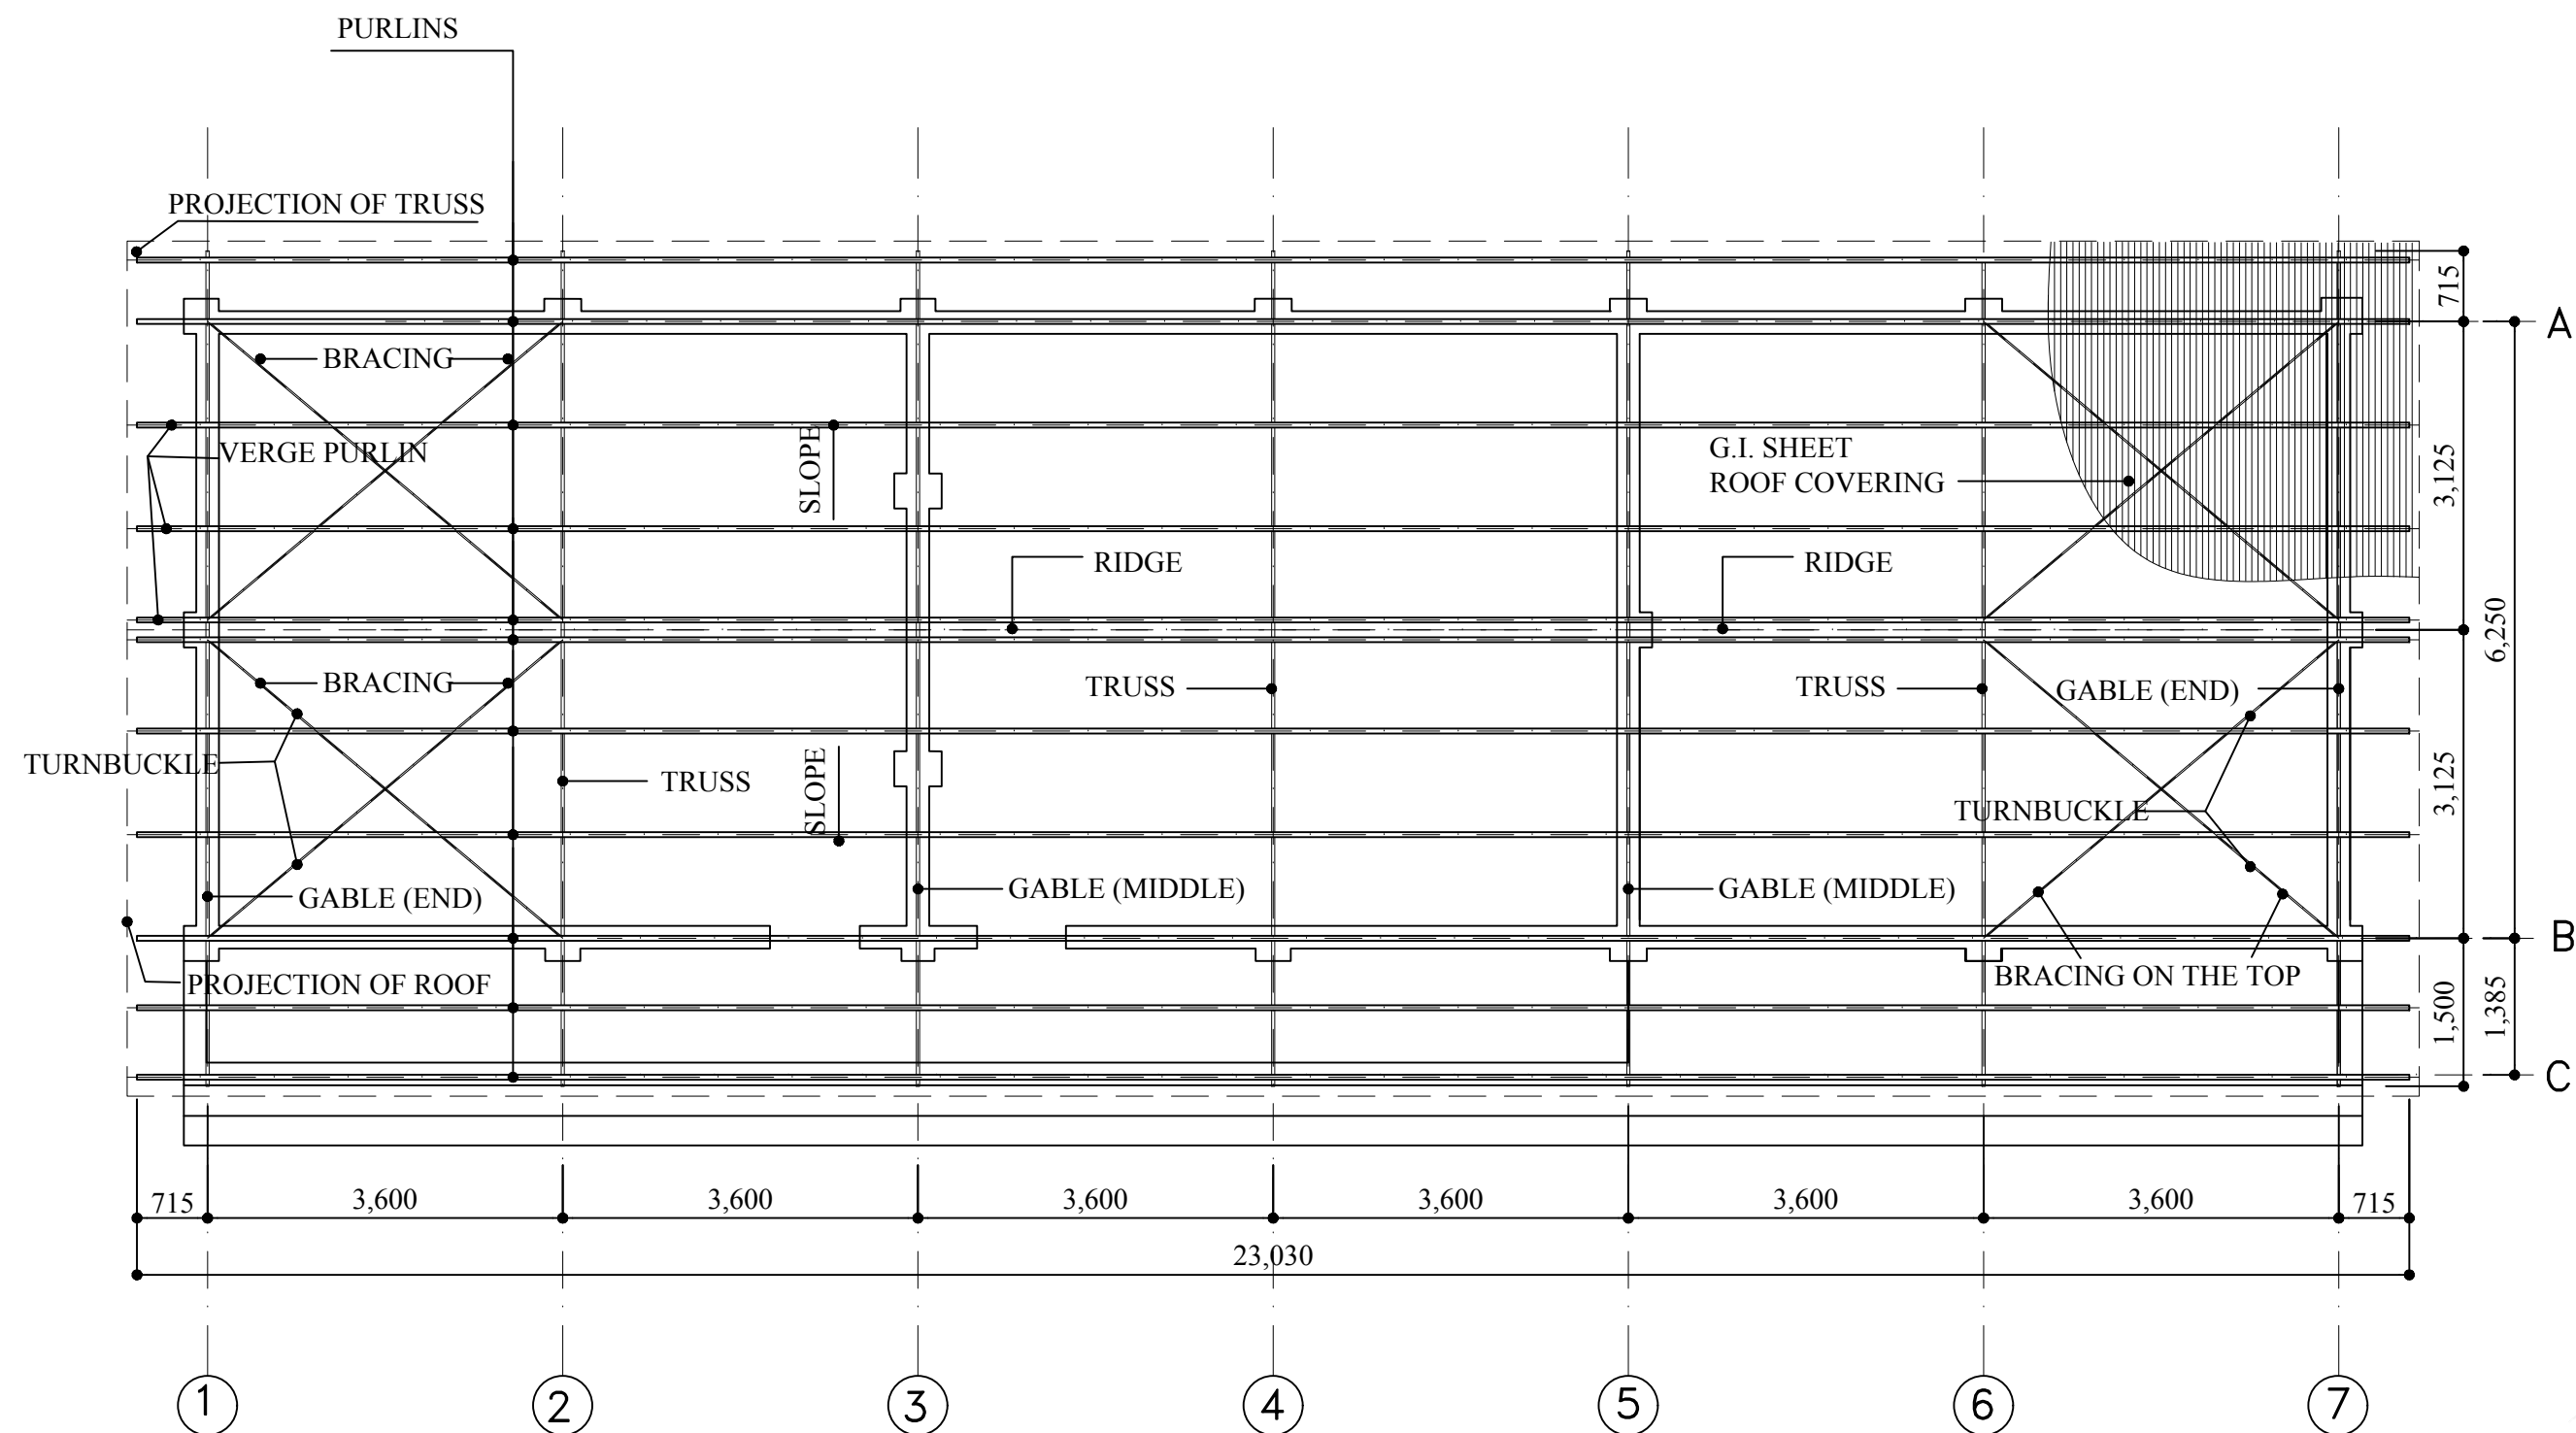



STRUCTURAL PLAN OF TRUSS

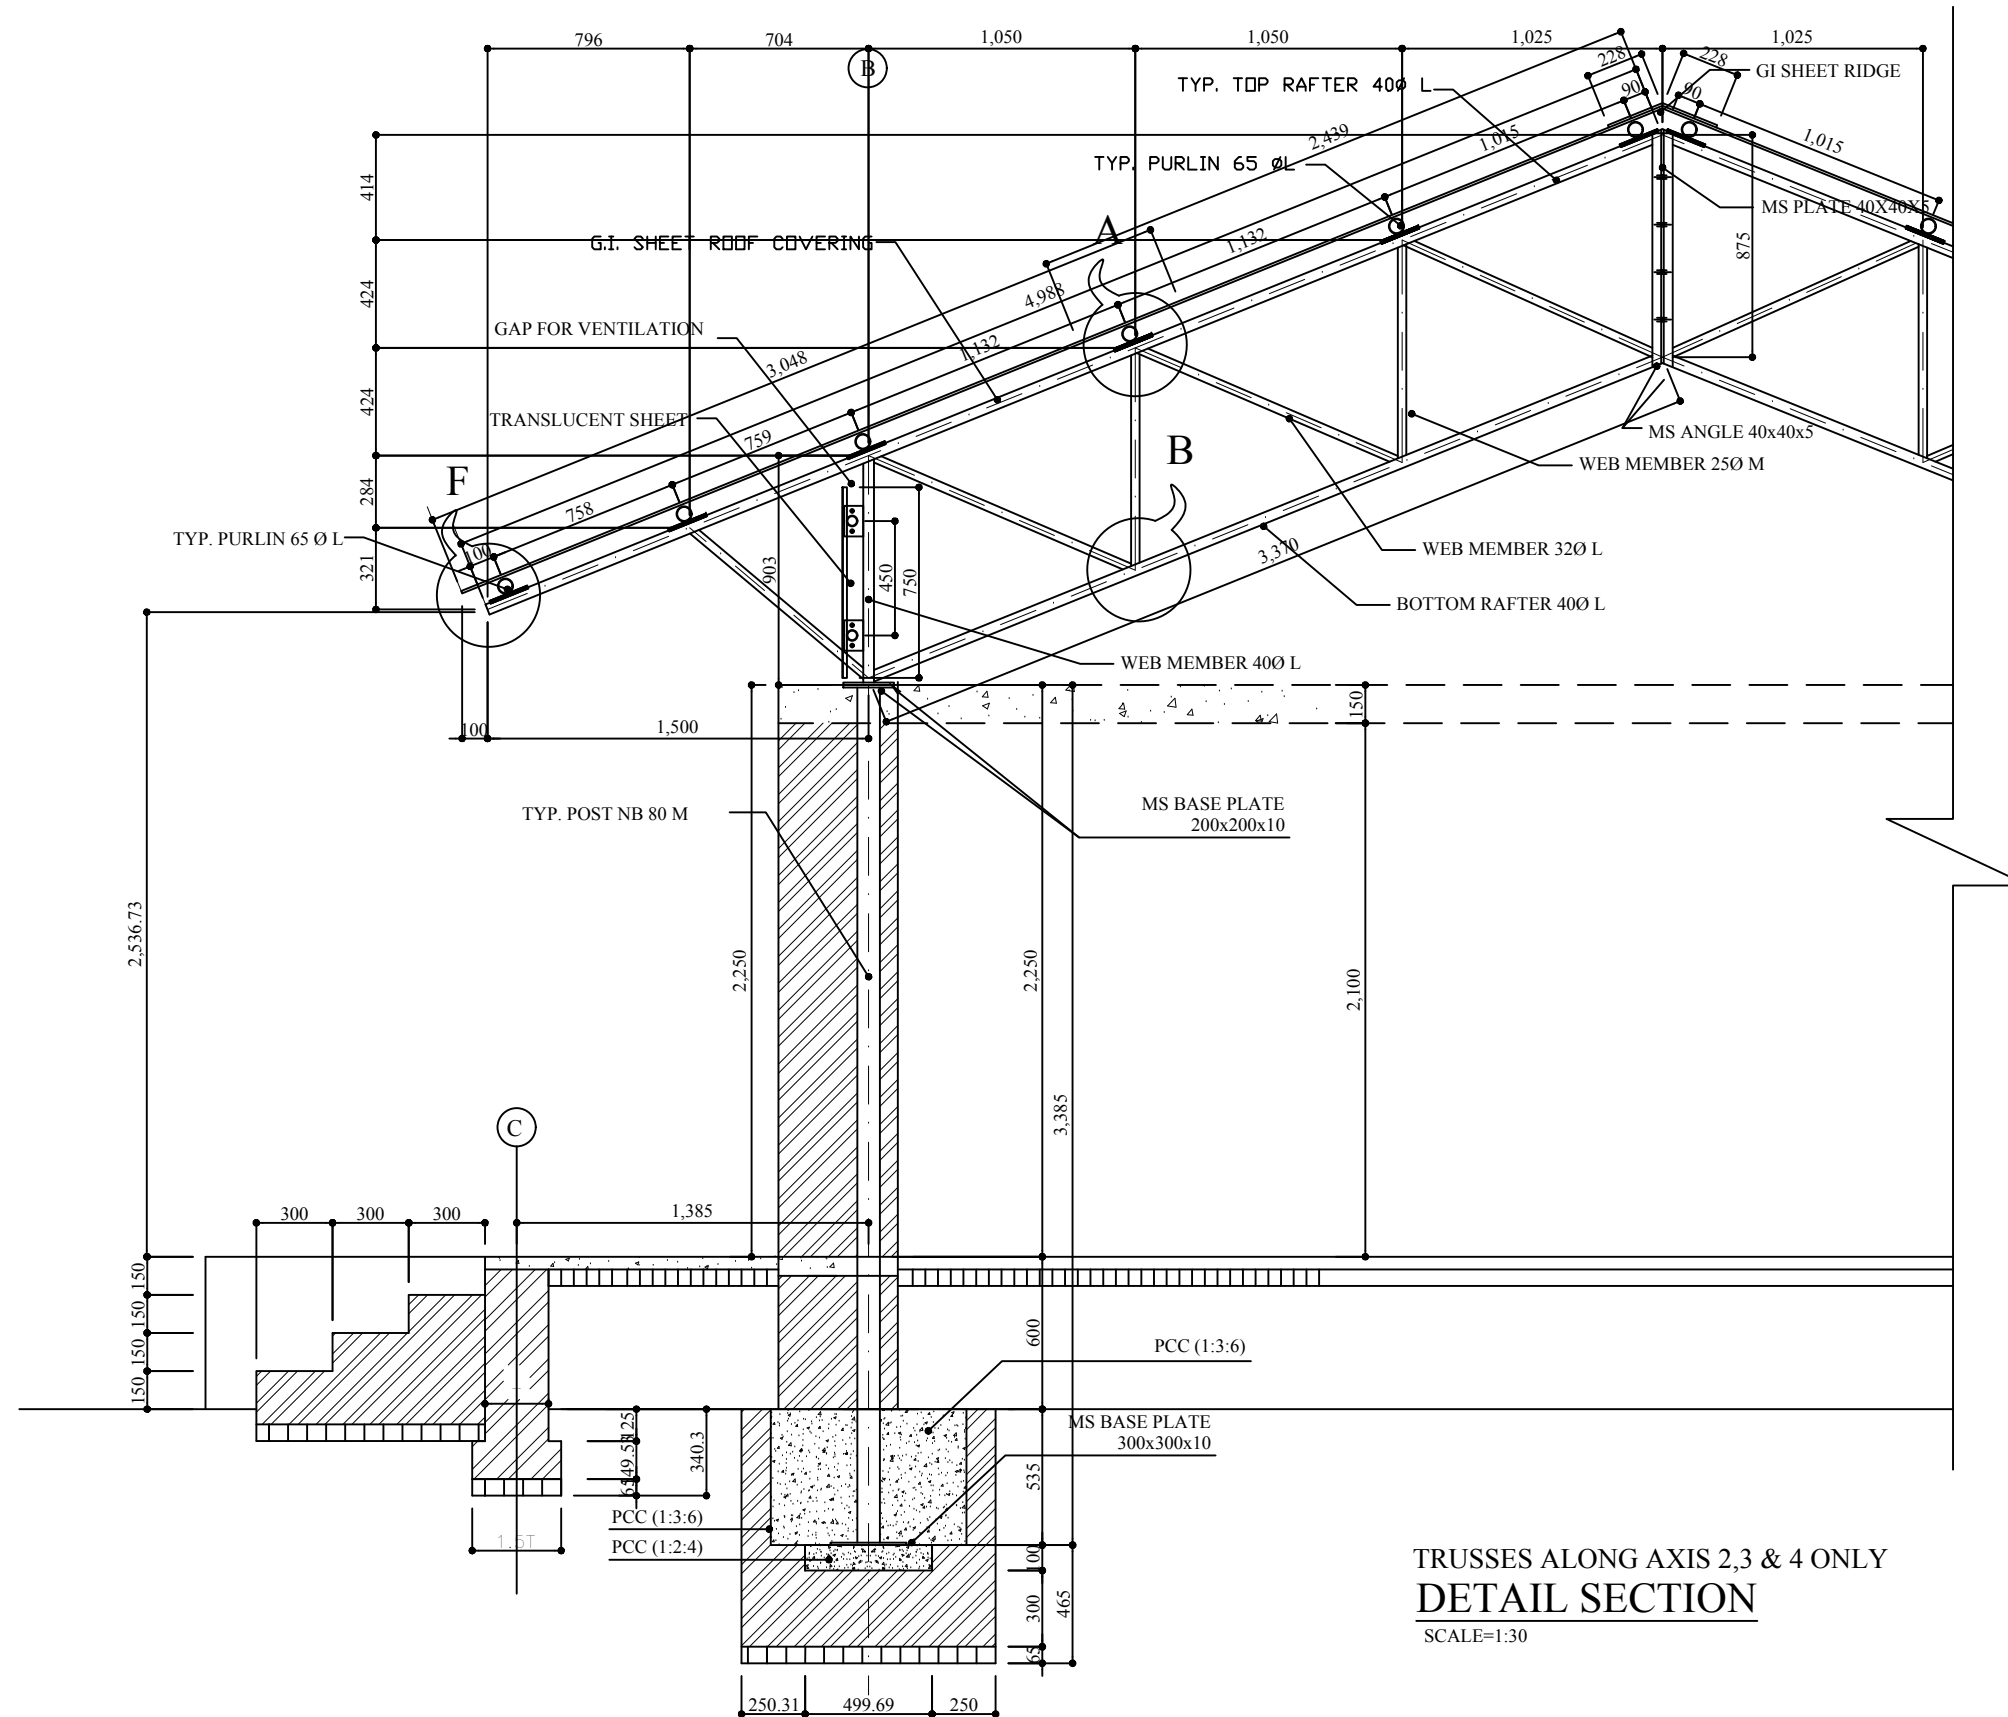

TRUSSES ALONG AXIS 2,3 & 4 ONLY
DETAIL SECTION
 SCALE=1:30



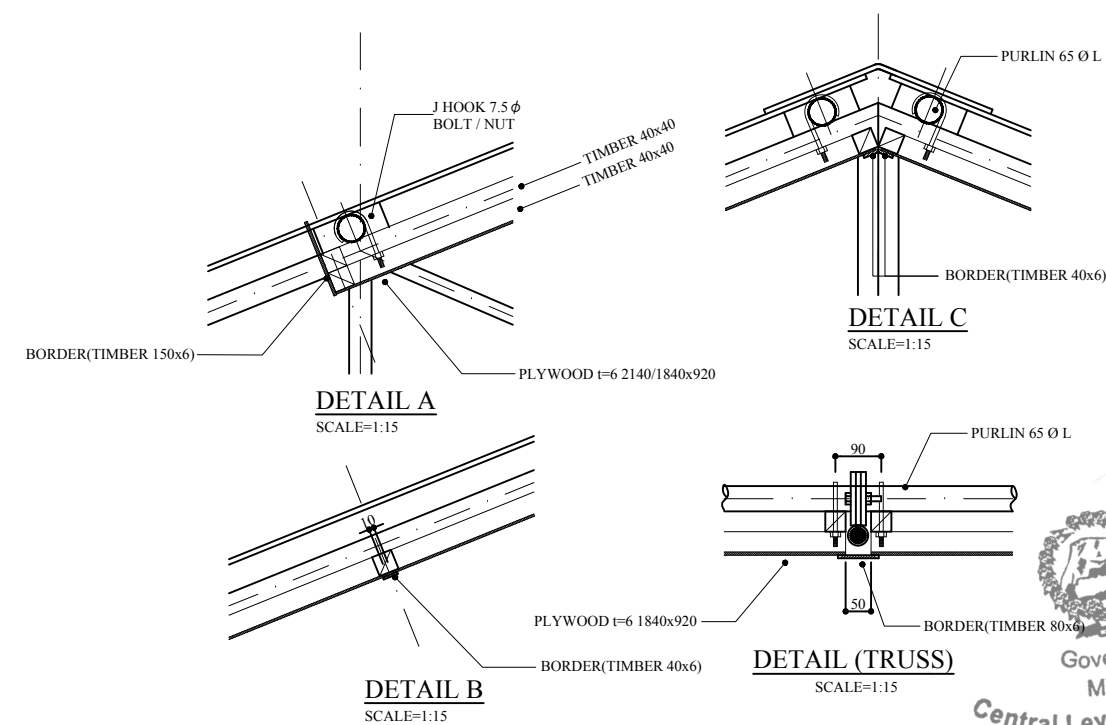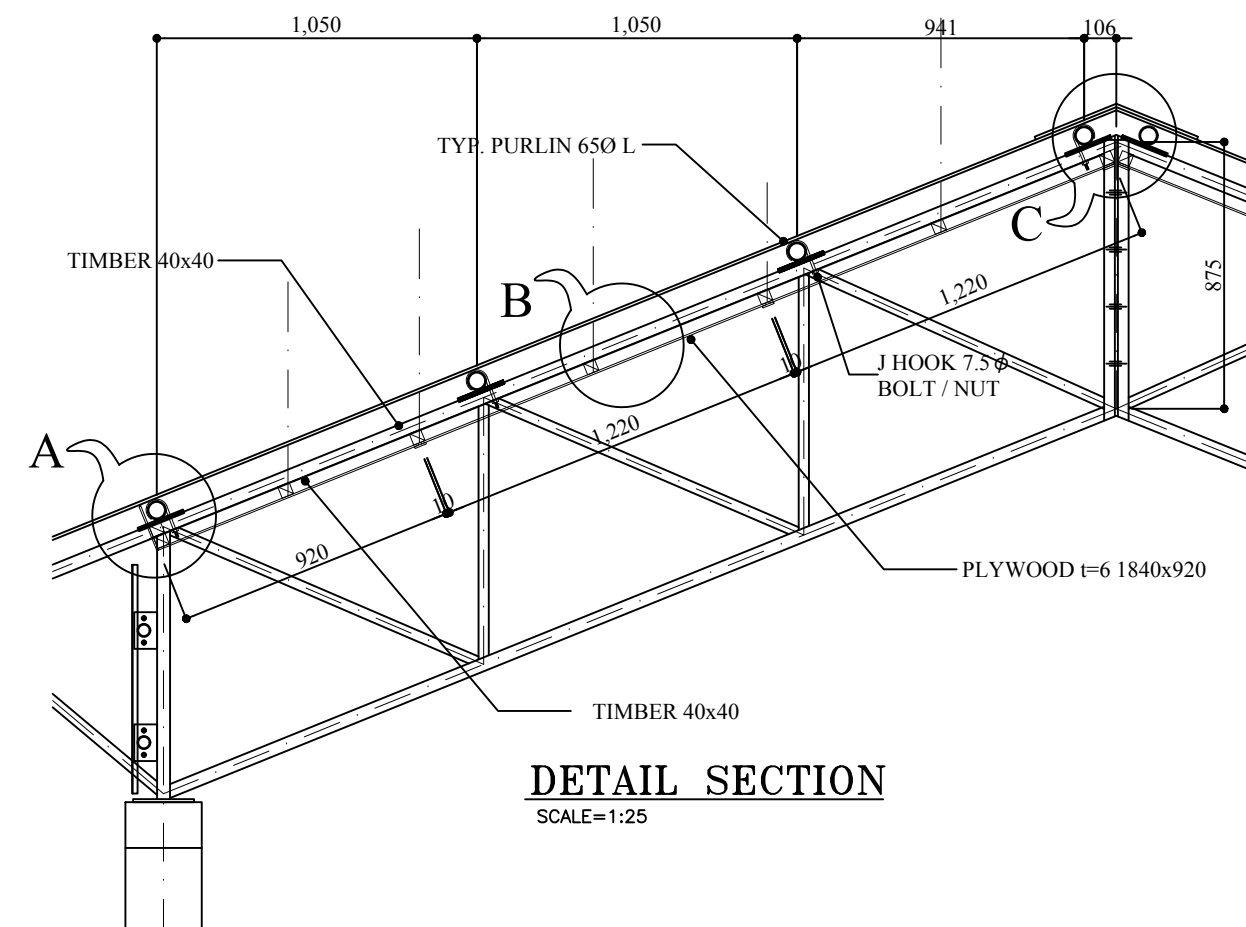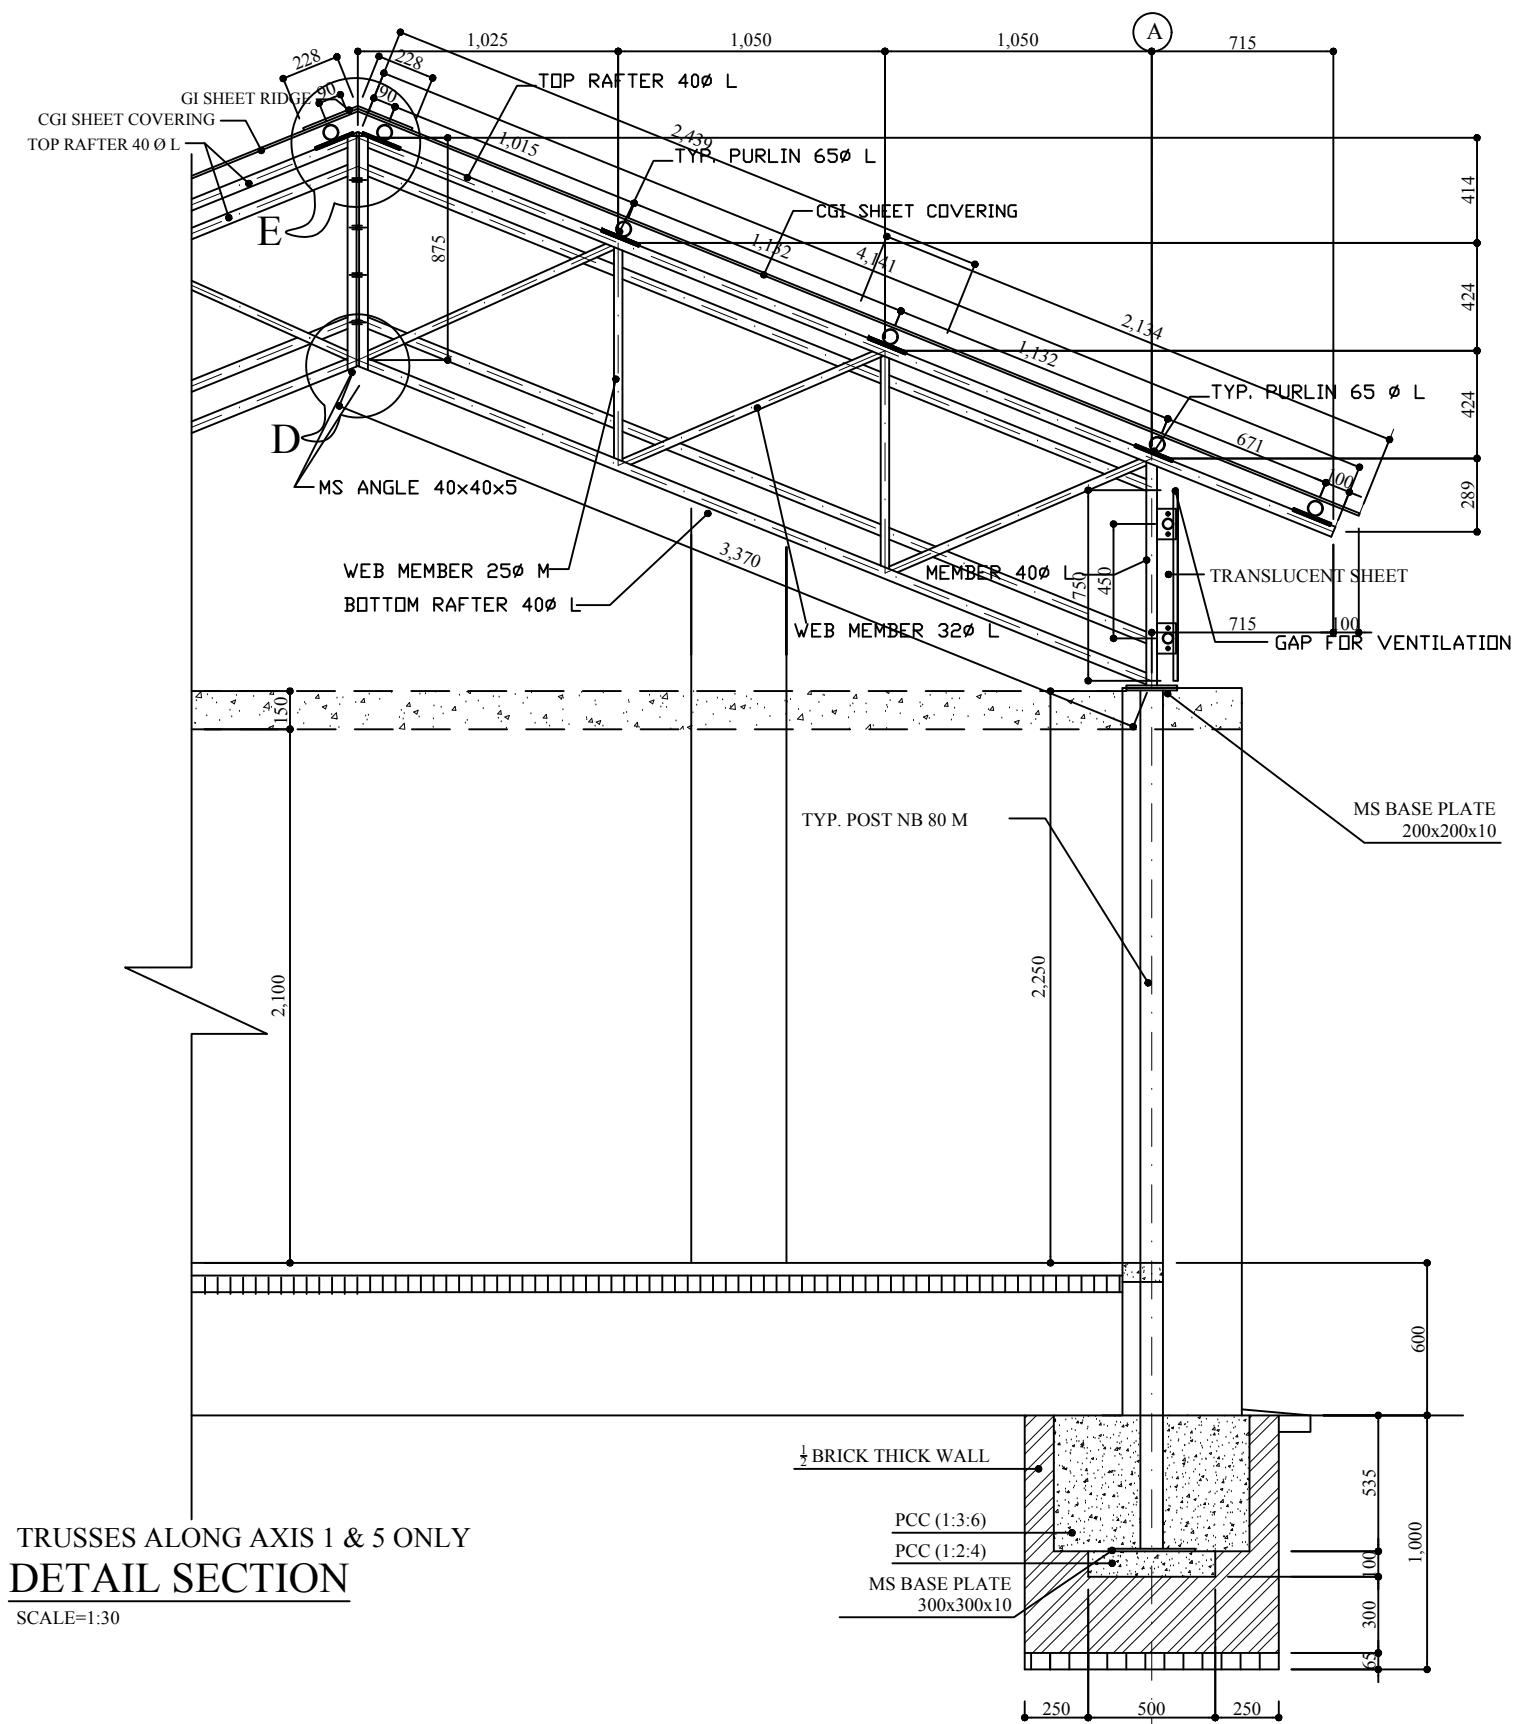


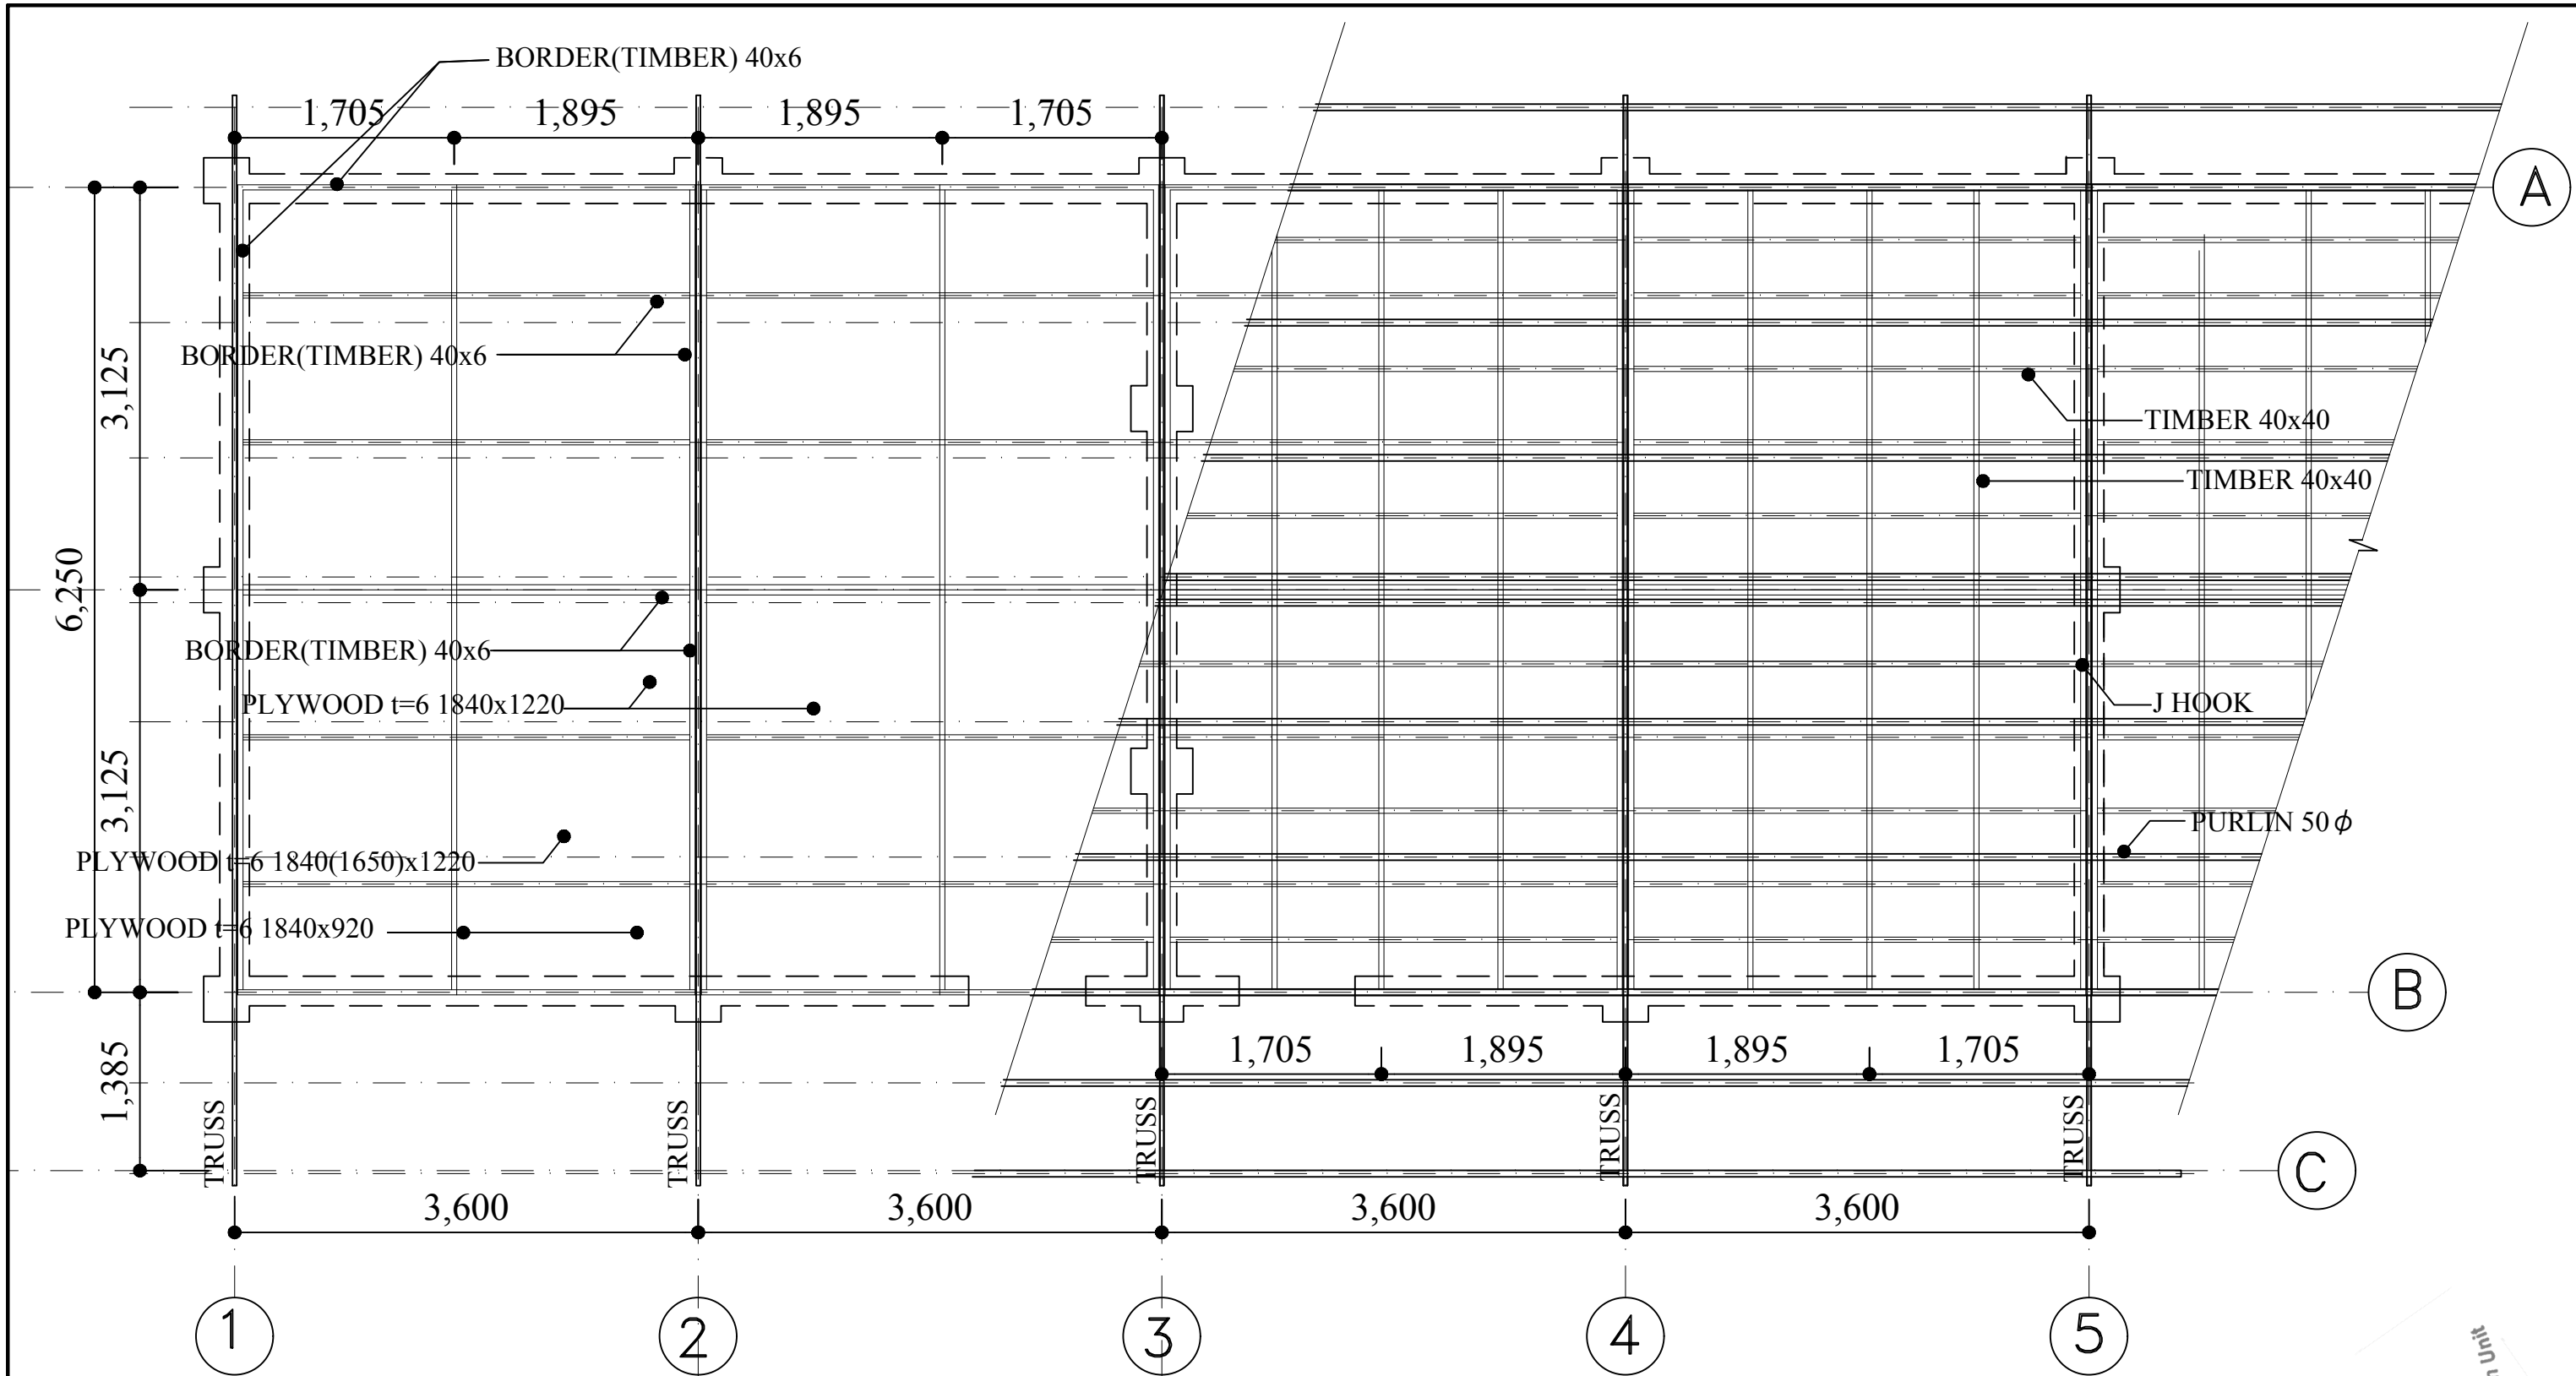


REFLECTED CEILING PLAN




Government of Nepal Ministry of Education Central Level Project Implementation Unit (CLPIU) Gyaneshwor, Kathmandu	PROJECT : 1 Storey 3 Classrooms Revised (Oct 2017)	TITLE : DETAIL SECTION OF TRUSS	Date : OCT 2017	Sheet No: 15
			Scale : 1:50	
			Designed by :	
			Checked by :	
			Approved by :	

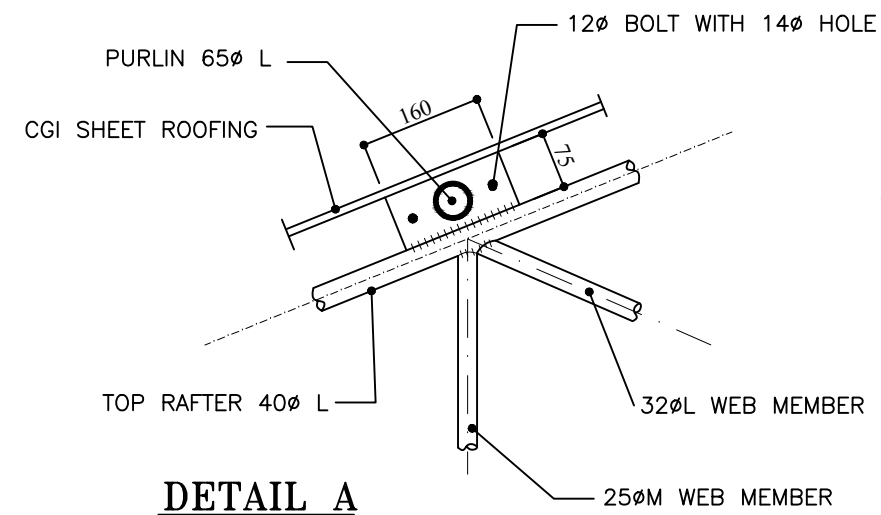


DETAIL A
SCALE=1:10

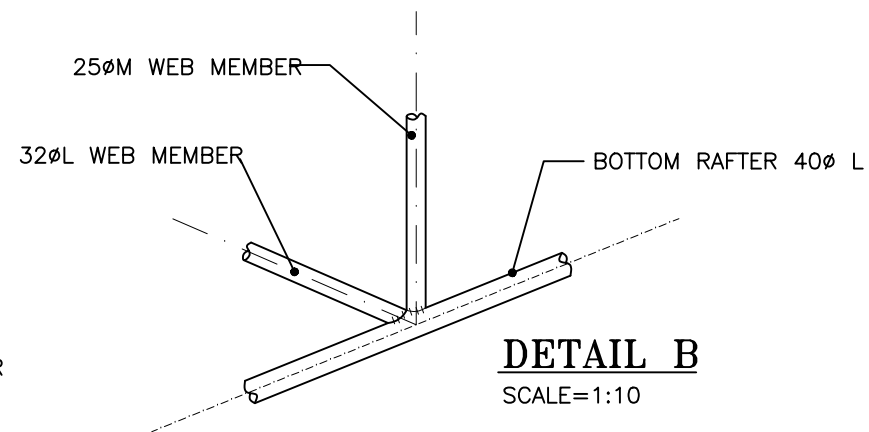


DETAIL B
SCALE=1:10

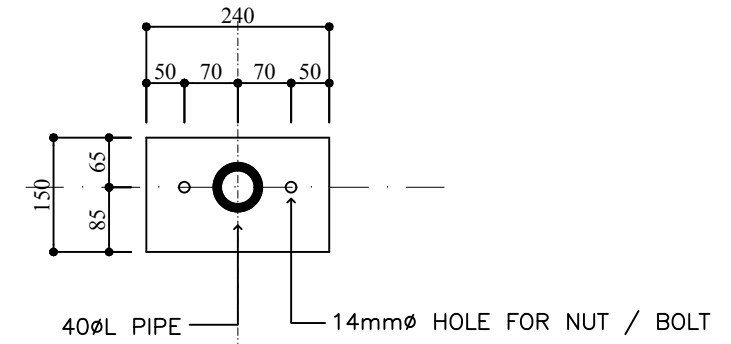


**240 x 150 x 6mm
MS PLATE ELEVATION**
SCALE=1:5

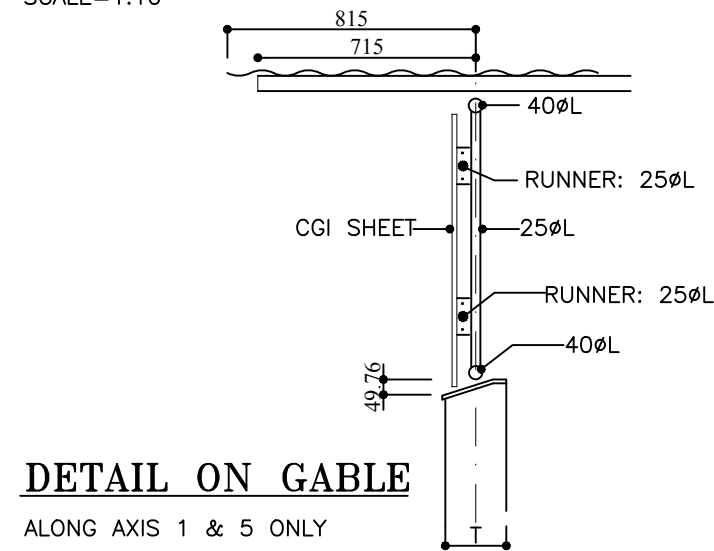


DETAIL ON GABLE
ALONG AXIS 1 & 5 ONLY
SCALE=1:25

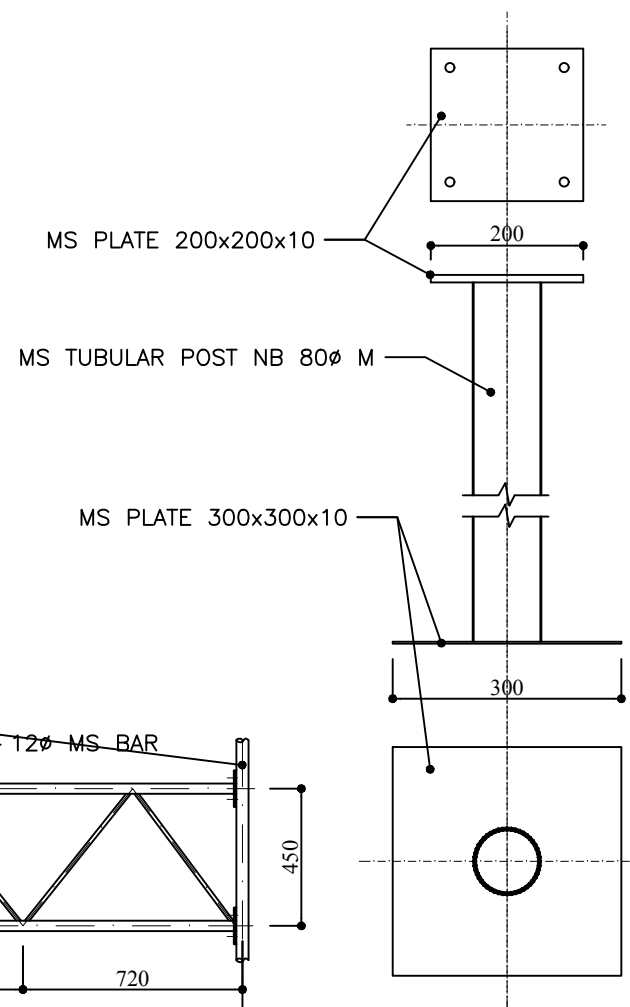


DETAIL OF POST
SCALE=1:10

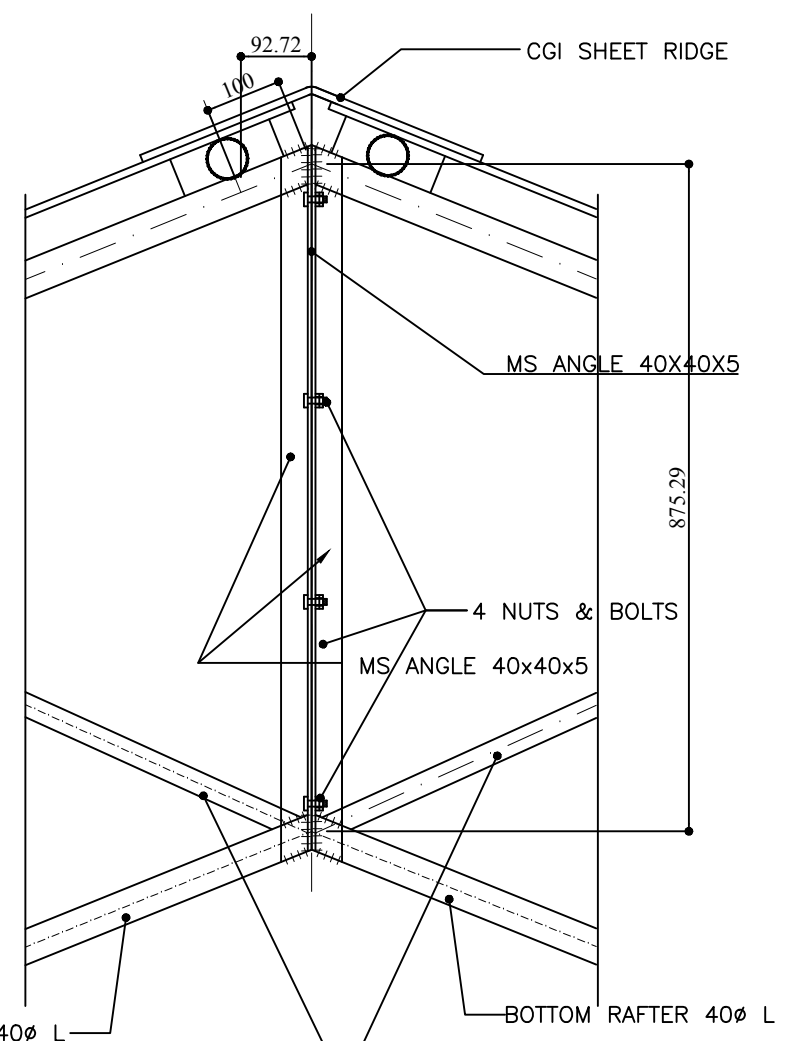

DETAIL D
SCALE=1:10

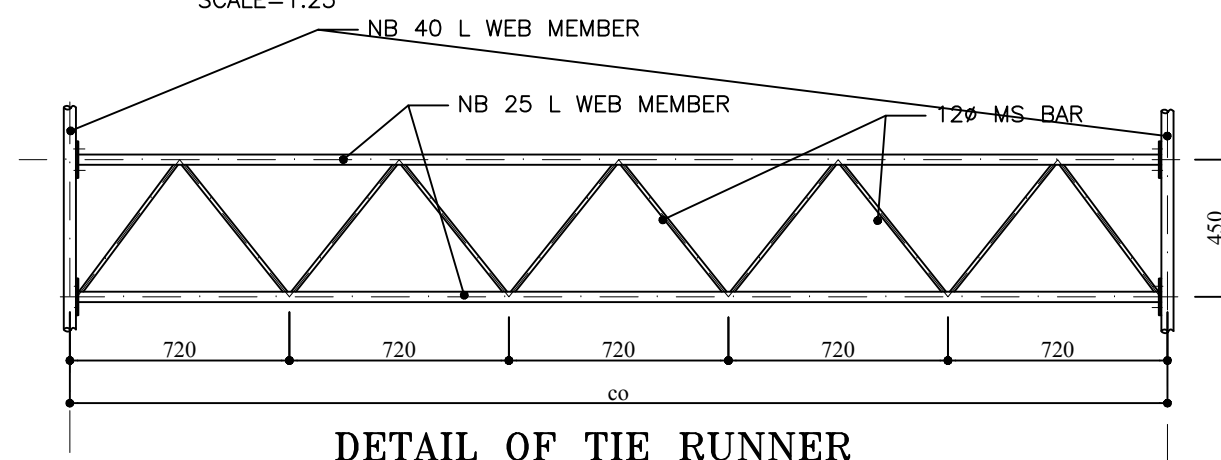


DETAIL OF TIE RUNNER
SCALE=1:25

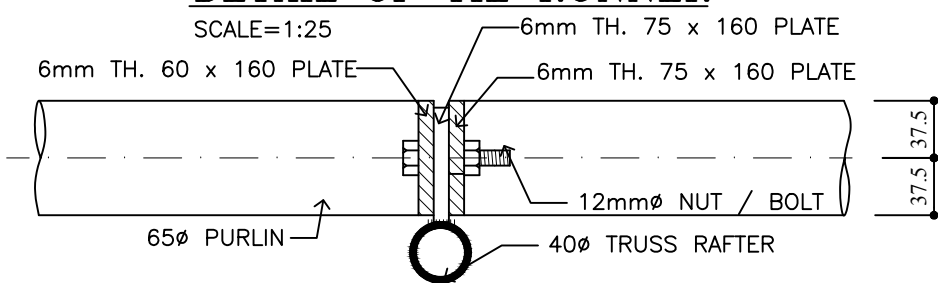


PURLIN JOINT DETAILS
SCALE=1:5




Government of Nepal Ministry of Education Central Level Project Implementation Unit (CLPIU) Gyaneshwor, Kathmandu	PROJECT : 1 Storey 3 Classrooms Revised (Oct 2017)	TITLE : DETAIL SECTION OF TRUSS	Date : OCT 2017	Sheet No: 16
			Scale : AS MENTIONED	
			Designed by :	
			Checked by :	
			Approved by :	

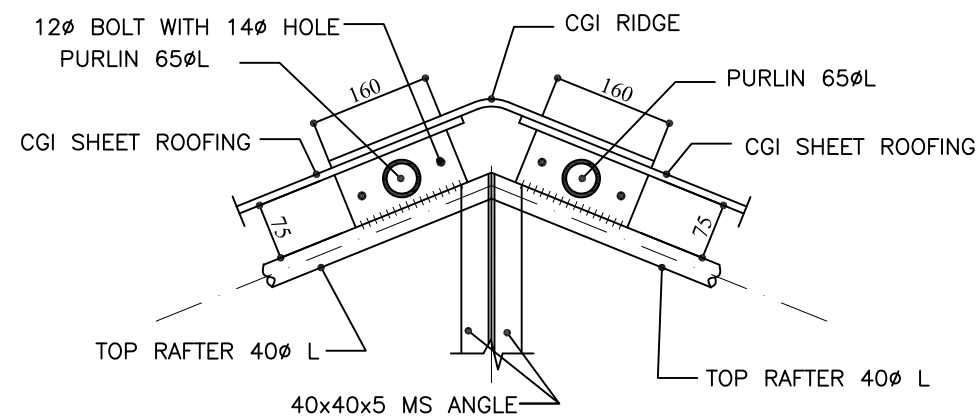


DETAIL E
SCALE=1:10

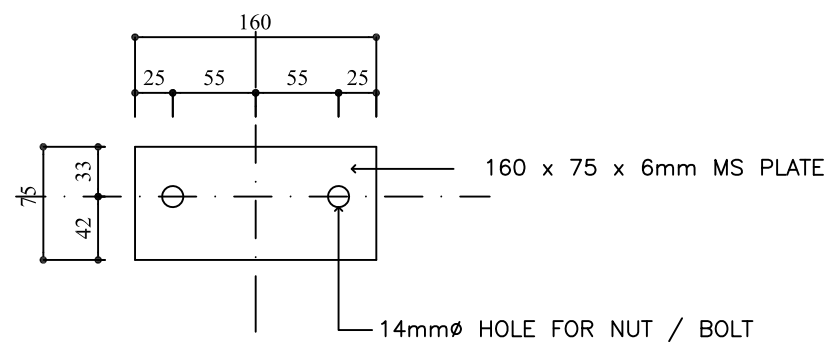


**160 x 75 x 6mm
MS PURLIN PLATE ON RAFTER**
SCALE=1:5

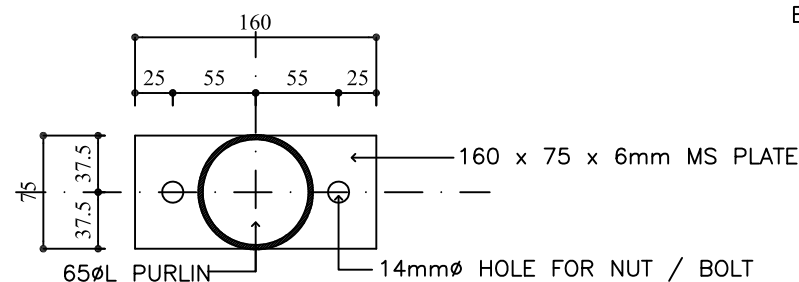


**160 x 75 x 6mm
MS PURLIN PLATES AT EDGES OF PURLINS**
SCALE=1:5

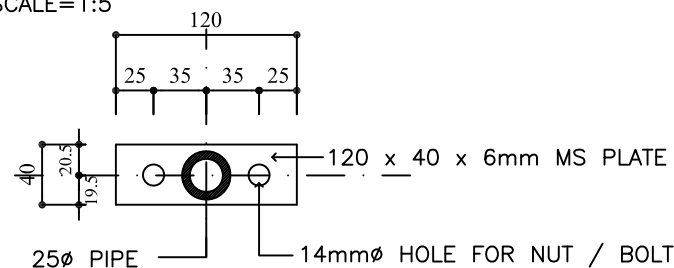


**120 x 40 x 6mm
MS PLATES AT EDGES OF 25Ø PIPES**
SCALE=1:5

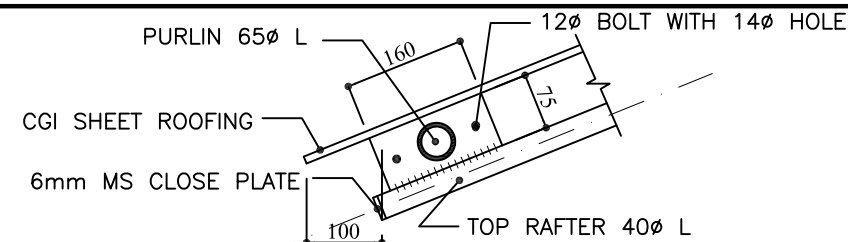


DETAIL F
SCALE=1:10

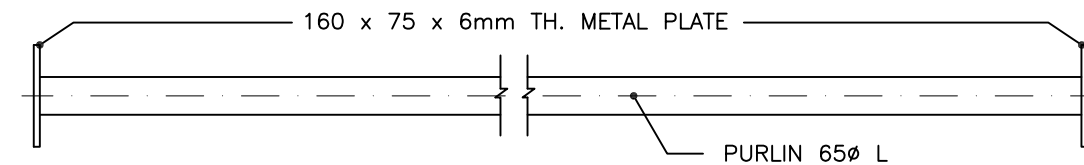


MIDDLE PURLIN DETAIL
SCALE 1:10

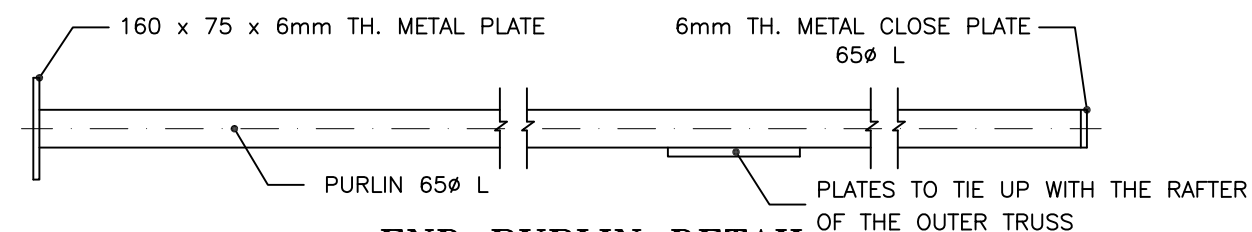


END PURLIN DETAIL
SCALE 1:10

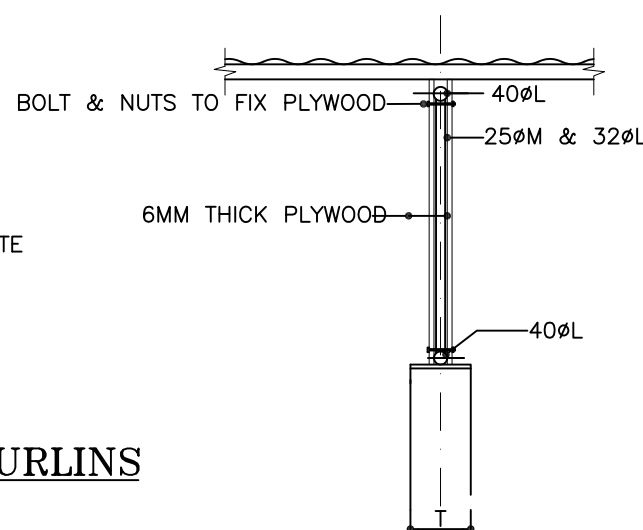

DETAIL ON MID GABLE
ALONG AXIS 4 ONLY
SCALE=1:25

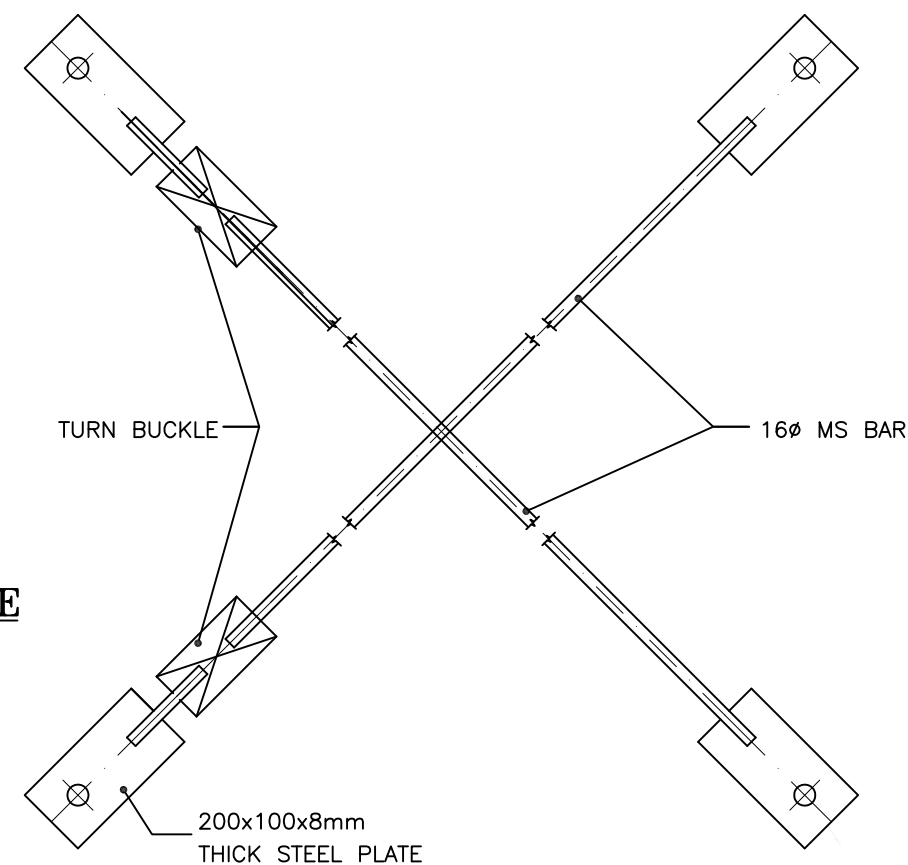

BRACE INTERSECTION DETAIL
SCALE 1:10

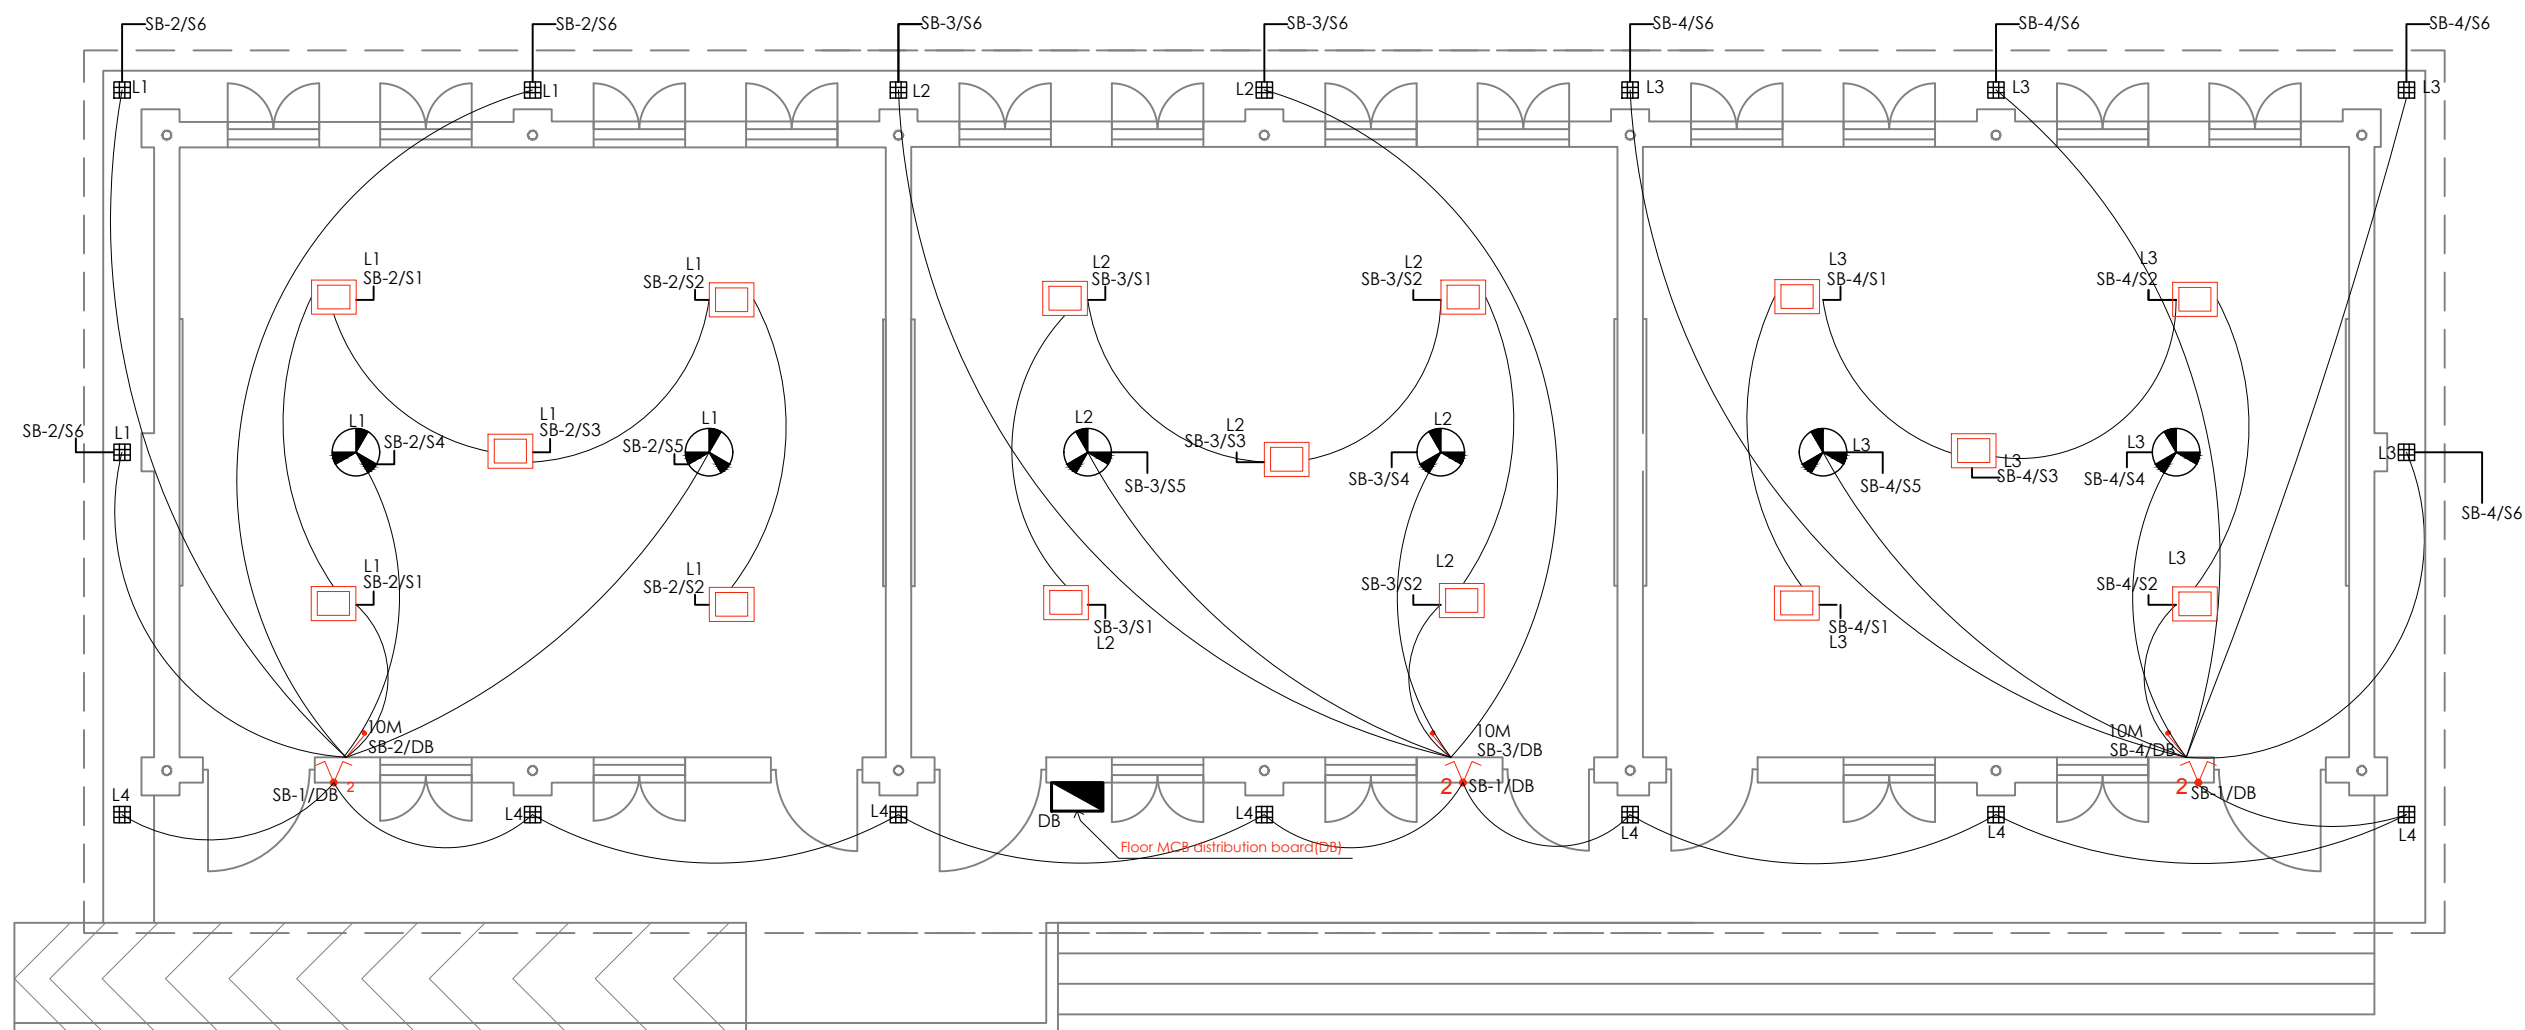


LIGHT LAYOUT PLAN

- PVC PIPE OF 20 mm dia 2MM THICK FOR CONCEALED WIRING SHOULD BE USED
- LIGHT/FAN/5A/16A SOCKET POINT 2X2.5 SQ. MM+1X 1.5 SQ MM(LNE)

LEGEND

S.N.	Particulars	Symbol
1	24 W LED Panel Light	
2	Floor MCB distribution board(DB)	
3	One way modular switch(Multi-gang)	
4	Two way modular switch	
5	6/16A 5 Pin switch socket outlet	
6	Ceiling Fan	
7	9W Square type LED Light	

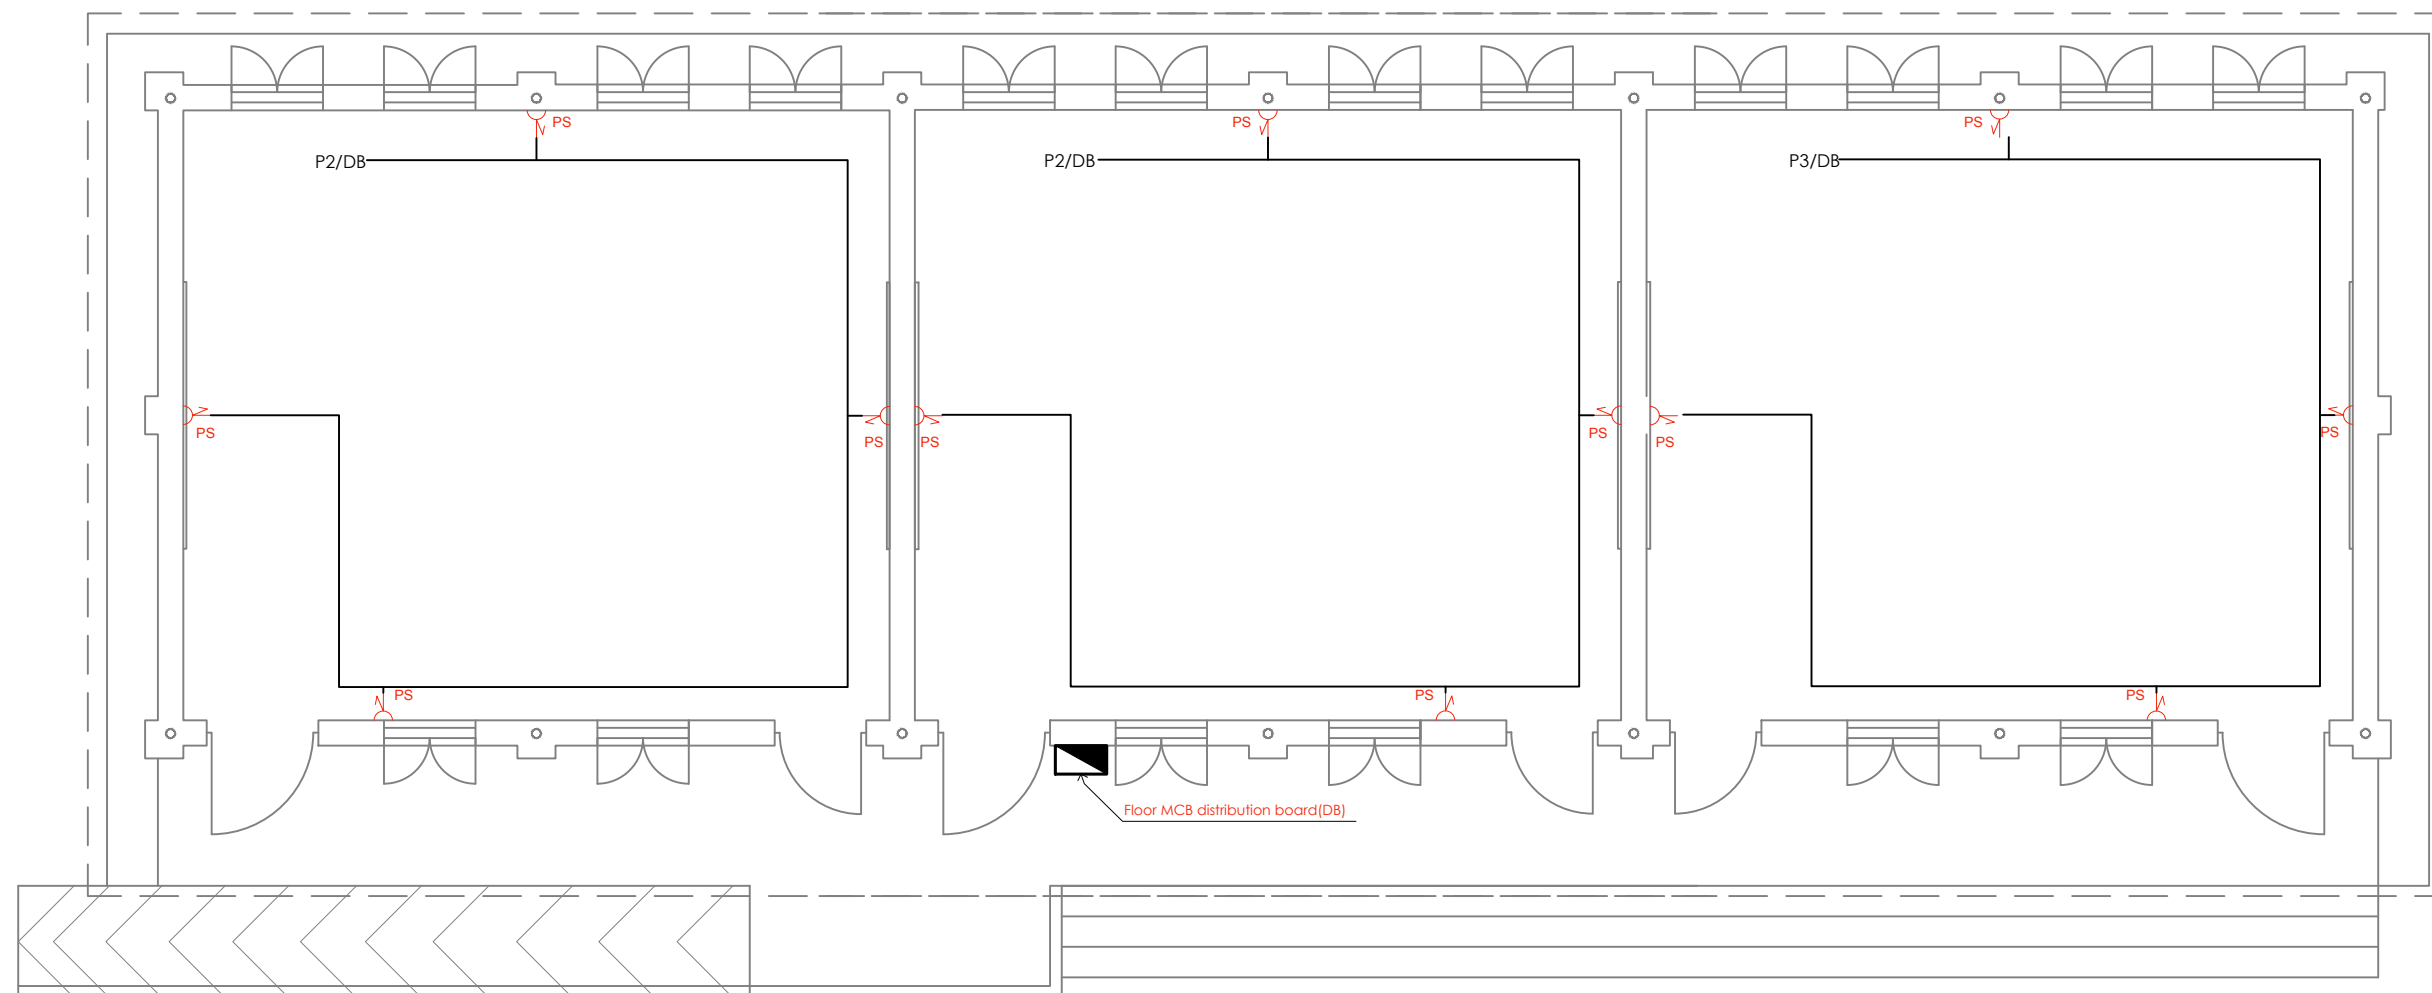

POWER POINT LAYOUT PLAN

LEGEND

S.N.	Particulars	Symbol
1	24 W LED Panel Light	
2	Floor MCB distribution board(DB)	
3	One way modular switch(Multi-gang)	
4	Two way modular switch	
5	6/16A 5 Pin switch socket outlet	
6	Ceiling Fan	
7	9W Square type LED Light	

